
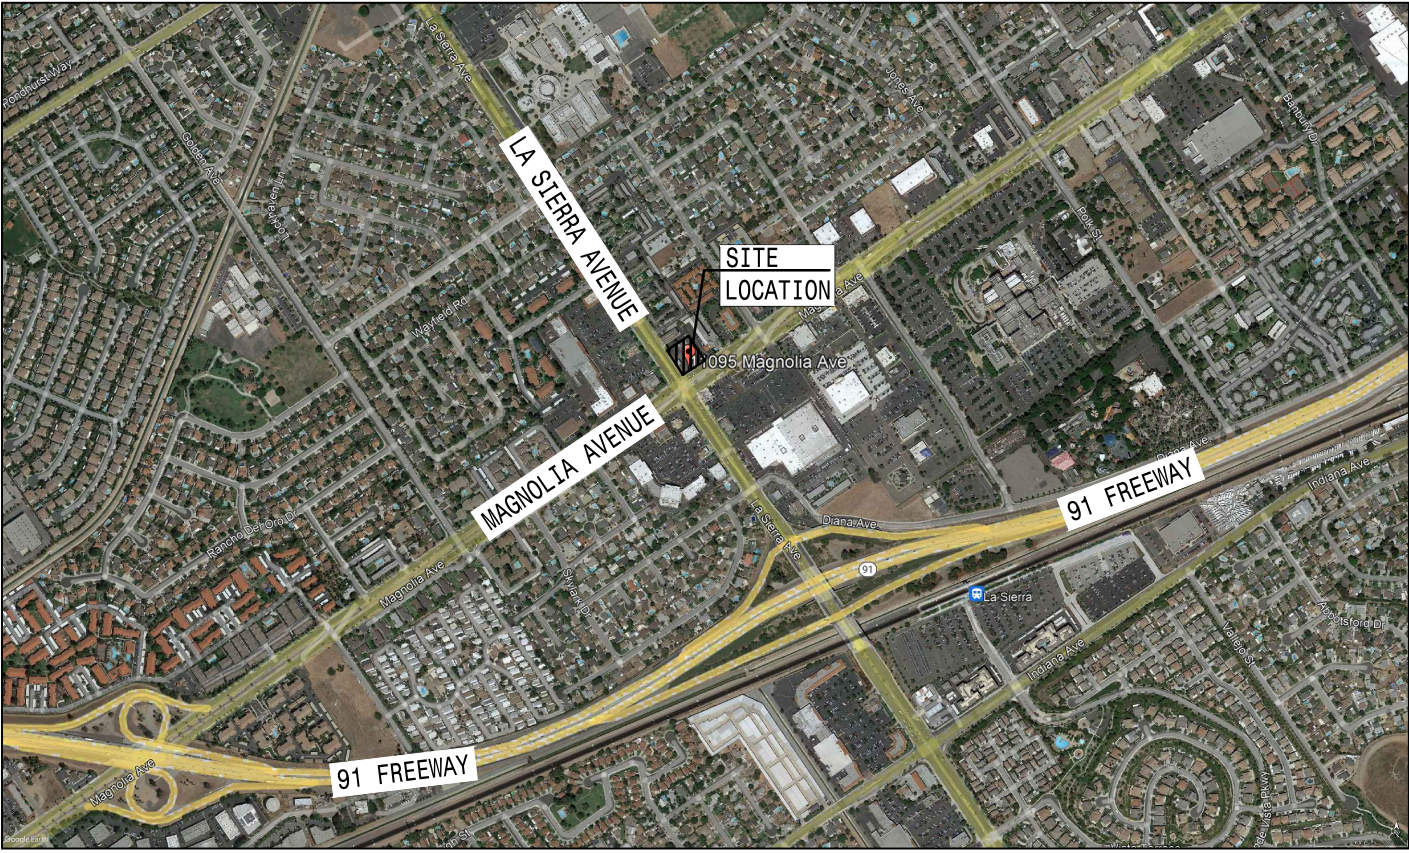


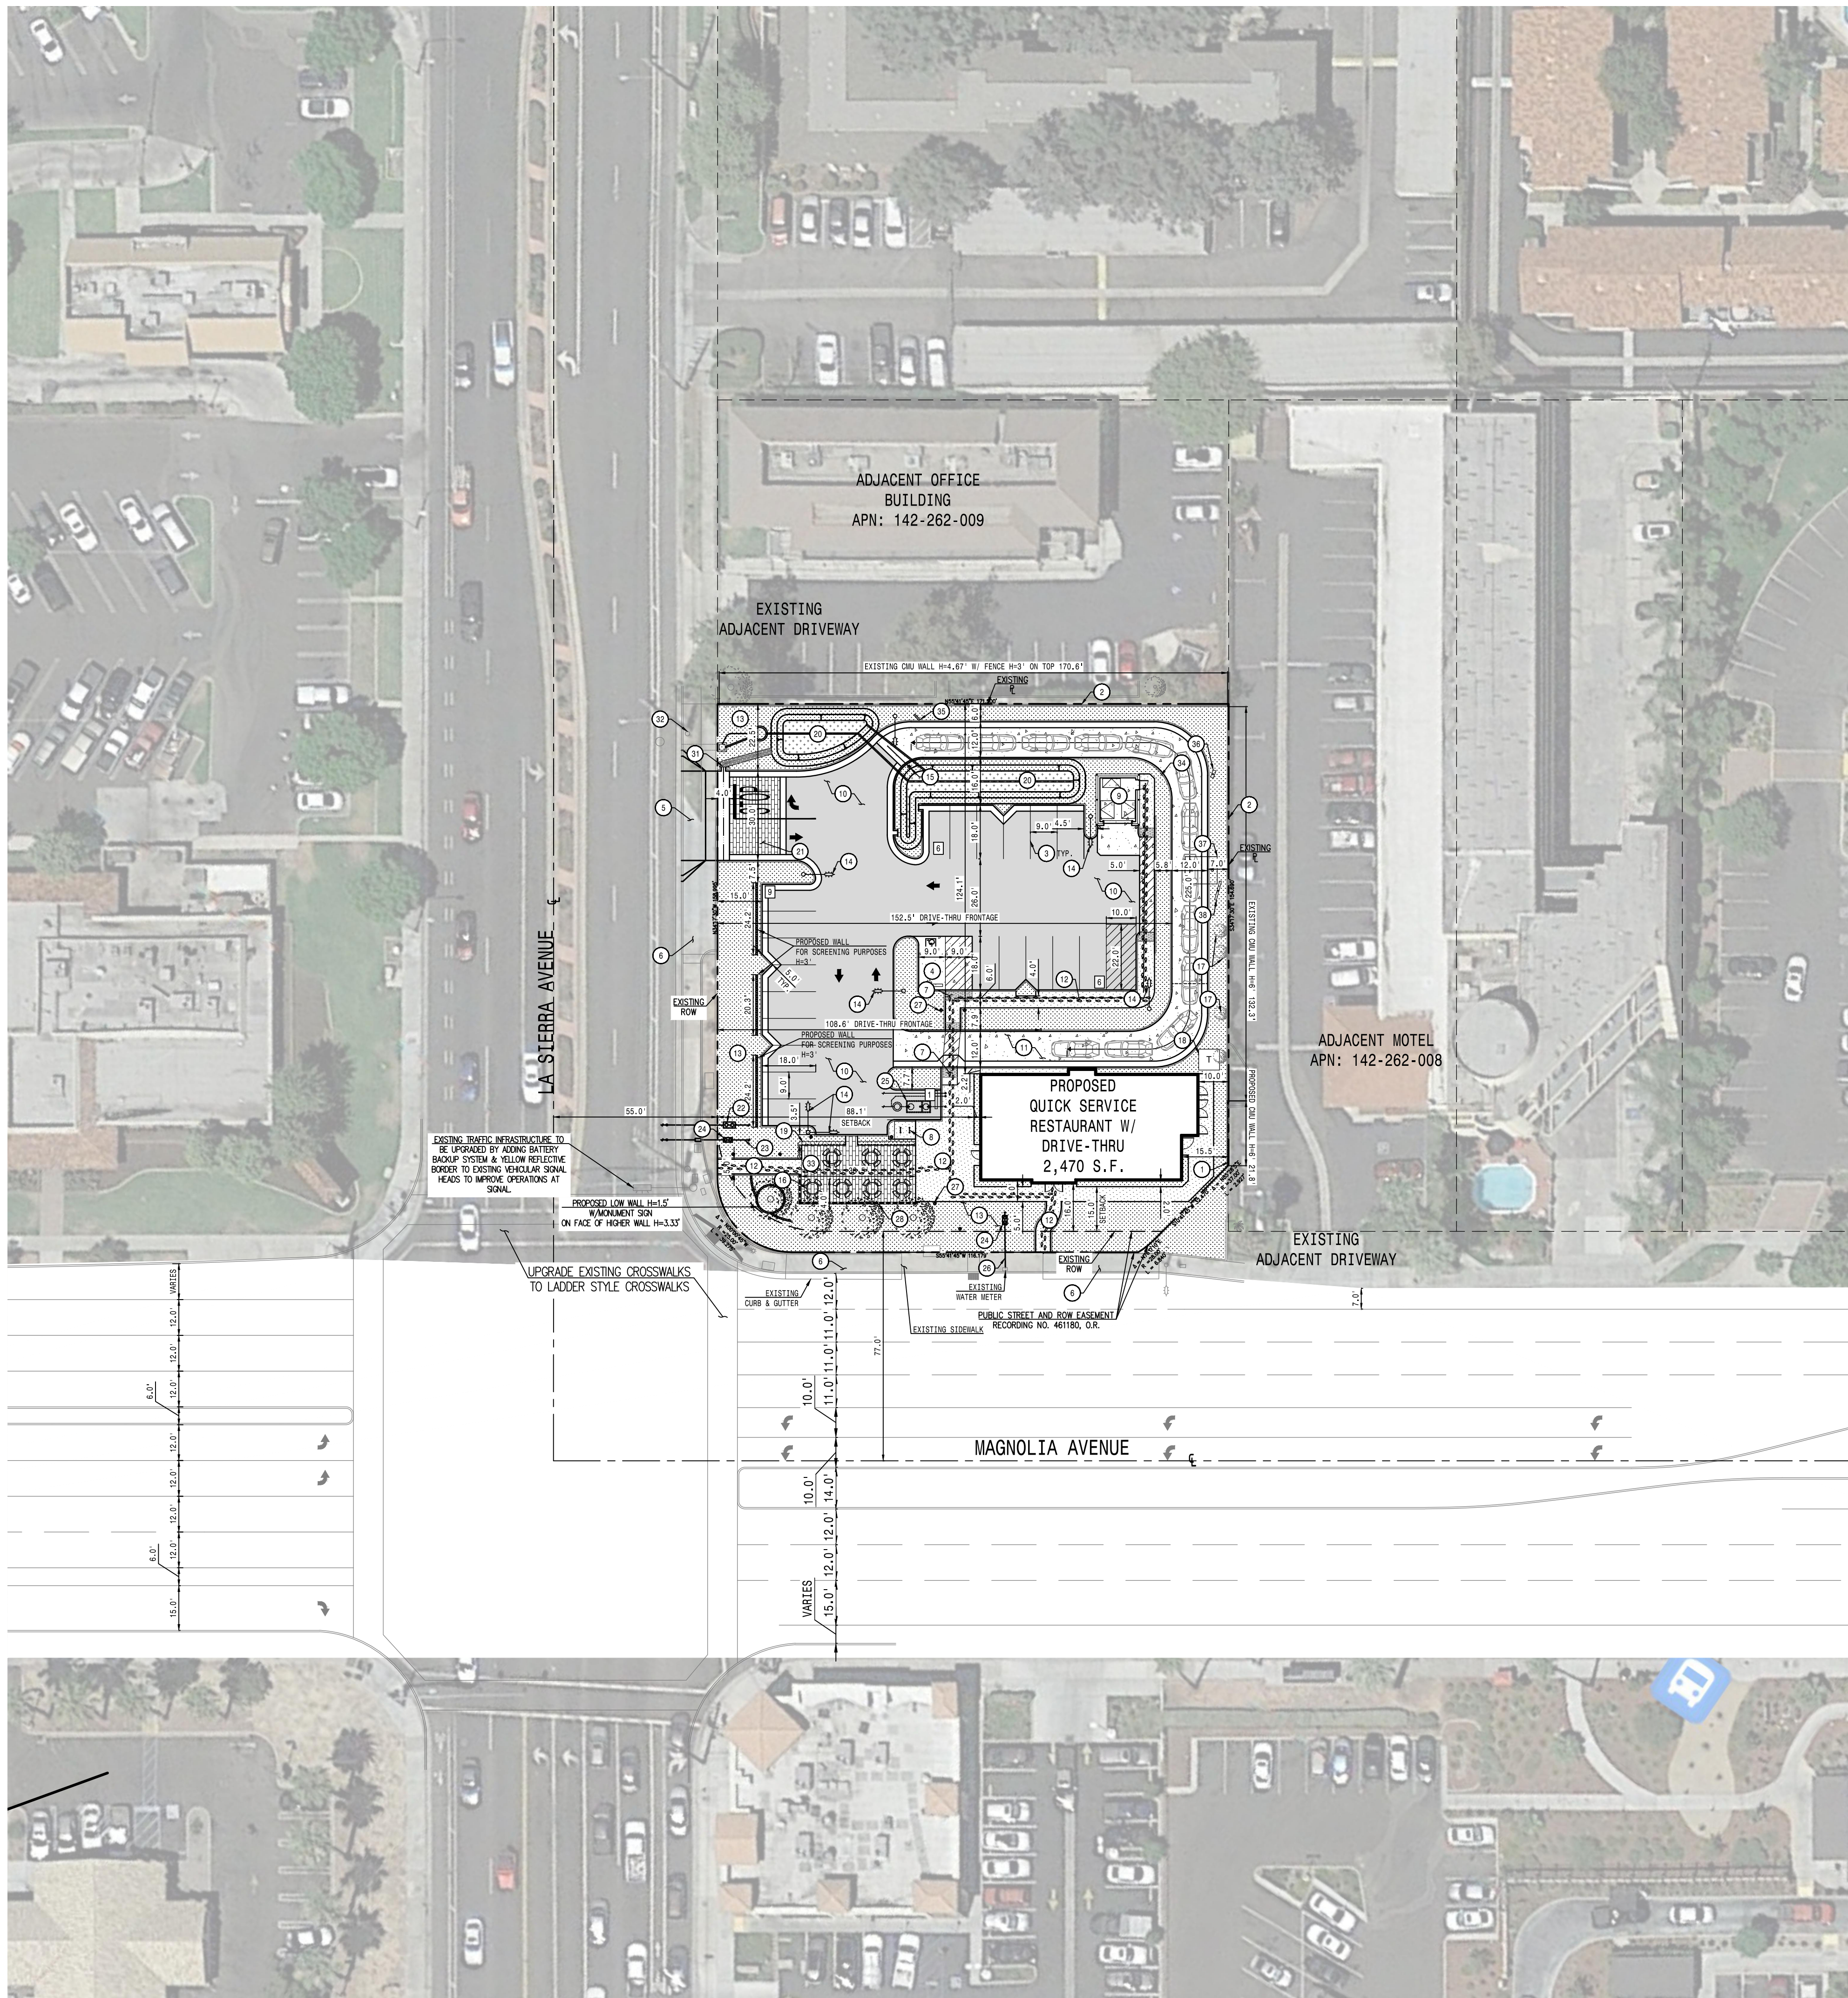

- LEGEND:**
- | | | | |
|--|---------------------|--|--------------------|
| | LANDSCAPE AREA | | AC PAVEMENT |
| | PCC CONCRETE | | PCC SIDEWALK |
| | POROUS PAVERS | | ADA PATH OF TRAVEL |
| | # OF PARKING STALLS | | |

- SHEET INDEX**
- | | | |
|------|---|-------------------------|
| C01 | - | CONCEPTUAL SITE PLAN |
| C02 | - | CONCEPTUAL GRADING PLAN |
| C03 | - | WQMP SITE PLAN |
| C04 | - | SITE SECTIONS |
| C05 | - | WALL PLAN |
| C06 | - | PLOT PLAN |
| E200 | - | SITE PHOTOMETRIC PLAN |
| A0.2 | - | TRASH ENCLOSURE DETAILS |
| A1.0 | - | FLOOR PLAN |
| A2.0 | - | EXTERIOR ELEVATIONS |
| A2.1 | - | EXTERIOR ELEVATIONS |
| A3.0 | - | ROOF PLAN |
| L001 | - | PLANTING SPECIFICATION |
| L101 | - | PLANTING PLAN |
| L501 | - | DETAILS |
| L901 | - | PLANT PALLET |

PROJECT INFORMATION:

APPLICANT: ABRAHAM KAHEN
10940 WILSHIRE BLVD, SUITE 1600
LOS ANGELES, CA 90024
(310)795-7183

ARCHITECT: PM DESIGN GROUP, INC.
38 EXECUTIVE PARK SUITE 310
IRVINE, CA 92614
(949)430-7051

CIVIL ENGINEER: PLUMP ENGINEERING, INC.
914 E. KATELLA AVENUE
ANAHEIM, CA 92805
(714)385-1835

SURVEYOR: PLUMP ENGINEERING, INC.
914 E. KATELLA AVENUE
ANAHEIM, CA 92805
(714)385-1835

PROJECT SCOPE OF WORK: DEMOLITION OF EXISTING BUILDINGS TO BE REPLACED WITH PROPOSED 2,470 S.F. QUICK-SERVICE RESTAURANT WITH DRIVE THRU, PARKING LOT (INCLUDING ADA IMPROVEMENTS) AND LANDSCAPING IMPROVEMENTS PROPOSED.

APN: 142-262-006 & 142-262-012

PROPERTY ADDRESS: 11095 MAGNOLIA AVENUE
RIVERSIDE, CA 92505

GROSS ACREAGE: 0.75 AC/30,995 S.F.

NET ACREAGE: 0.70 AC/30,995 S.F.

PERVIOUS AREA: 9,304 S.F. (30.70% OF TOTAL SITE)

IMPERVIOUS AREA: 20,996 S.F. (69.30% OF TOTAL SITE)

ZONE: CR

ZONE AREA: NOT IN A ZONING DISTRICT/AREA

LAND USE: CITY

SPECIFIC PLAN: NOT IN A SPECIFIC PLAN

AREA PLAN: CITIES OF RIVERSIDE AND NORCO

POLICY AREA: N/A

FEMA FLOOD ZONE: ZONE X

MAP NUMBER: 06065C07156

PARKING CALCULATIONS: PER AB-2097, PROJECT IS EXEMPT FROM PARKING REQUIREMENTS.


PARKING PROVIDED: 21 REGULAR PARKING STALLS
1 ADA PARKING STALL (1 REQUIRED)
22 TOTAL PARKING STALLS

BICYCLE PARKING REQUIRED: 5% OF 22 = 2

BICYCLE PARKING PROVIDED: 2 BICYCLE PARKING


SITE PLAN KEYNOTES

- | | | | |
|----|---|----|---|
| 1 | EXISTING WROUGHT IRON FENCE TO BE REMOVED AND DISPOSED OFF SITE | 31 | FURNISH AND INSTALL STOP SIGN PER CITY STANDARDS |
| 2 | EXISTING SCREEN WALL TO REMAIN | 32 | EXISTING POWER POLE TO BE PROTECTED IN PLACE |
| 3 | PROPOSED PARKING STALLS 9'x18' PER CITY STANDARDS | 33 | PROPOSED POROUS PAVER WALKWAY |
| 4 | PROPOSED ADA PARKING STALL PER CITY STANDARDS | 34 | PROPOSED 3' HIGH LANDSCAPE HEDGES FOR DRIVE-THRU SCREENING PURPOSES |
| 5 | PROPOSED DRIVEWAY | 35 | PROPOSED DRIVE THRU ENTRY SIGN PER SEPARATE PERMIT |
| 6 | EXISTING DRIVEWAY TO BE REMOVED AND REPLACED WITH SIDEWALK, CURB & GUTTER | 36 | PROPOSED PRE-ORDER MENU BOARD PER SEPARATE PERMIT |
| 7 | PROPOSED ADA RAMP | 37 | PROPOSED DRIVE-THRU CANOPY PER ARCHITECTURAL COLORED ELEVATIONS |
| 8 | PROPOSED BIKE RACK | 38 | PROPOSED ORDER MENU BOARD PER SEPARATE PERMIT |
| 9 | PROPOSED TRASH ENCLOSURE TO BE SCREENED PER SECTION 19.580.080 OF THE RMC | | |
| 10 | PROPOSED AC/AB PAVEMENT | | |
| 11 | PROPOSED CONCRETE DRIVE-THRU PAVEMENT | | |
| 12 | PROPOSED CONCRETE WALKWAY | | |
| 13 | PROPOSED LANDSCAPE AREA | | |
| 14 | PROPOSED LIGHT POLE | | |
| 15 | PROPOSED CLEARANCE BAR PER ARCHITECTURAL COLORED ELEVATIONS | | |
| 16 | PROPOSED PATIO SEATING | | |
| 17 | EXISTING TREE TO BE PROTECTED IN PLACE | | |
| 18 | PROPOSED ELECTRIC TRANSFORMER TO BE SCREENED PER SECTION 19.555.020.C.1 OF THE RMC | | |
| 19 | PROPOSED 3' HIGH LANDSCAPE HEDGE WALL | | |
| 20 | PROPOSED BIO-RETENTION BASIN | | |
| 21 | ENHANCED DRIVEWAY PAVING | | |
| 22 | FURNISH & INSTALL 4" FIRE SERVICE | | |
| 23 | FURNISH & INSTALL 2" DOMESTIC WATER SERVICE | | |
| 24 | FURNISH & INSTALL BACKFLOW PREVENTION DEVICE TO BE SCREENED PER SECTION 19.555.020.C.1 OF THE RMC | | |
| 25 | FURNISH & INSTALL 750 GAL GREASE INTERCEPTOR | | |
| 26 | EXISTING 1" WATER SERVICE FOR IRRIGATION PURPOSES | | |
| 27 | FURNISH & INSTALL PEDESTRIAN LIGHTS | | |
| 28 | PROPOSED DECORATIVE WALL FOR PATIO AREA H=3' | | |
| 29 | FURNISH & INSTALL TREE WELL | | |
| 30 | FURNISH & INSTALL 5x5' LANDSCAPE DIAMOND | | |

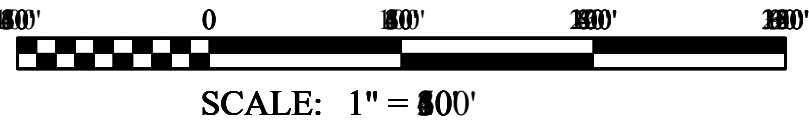

C01

NO.	DATE	REVISION DESCRIPTION	APPD.	DATE

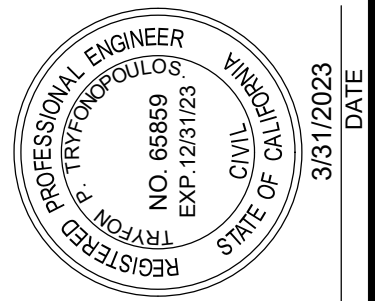

PLUMP ENGINEERING INC.
CONSULTING ENGINEERS IN
CIVIL/STRUCTURAL
ENGINEERING & SURVEYING

ABRAHAM KAHEN
914 E. KATELLA AVENUE
ANAHEIM, CA 92805
(714)385-1835

inc
PLUMP ENGINEERING INC.


CONCEPTUAL SITE PLAN
POLLO CAMPERO
11095 MAGNOLIA AVENUE
RIVERSIDE, CA

JOB NO. 2205041

DATE: 3/31/2023

SHEET

1 OF 6 SHEETS

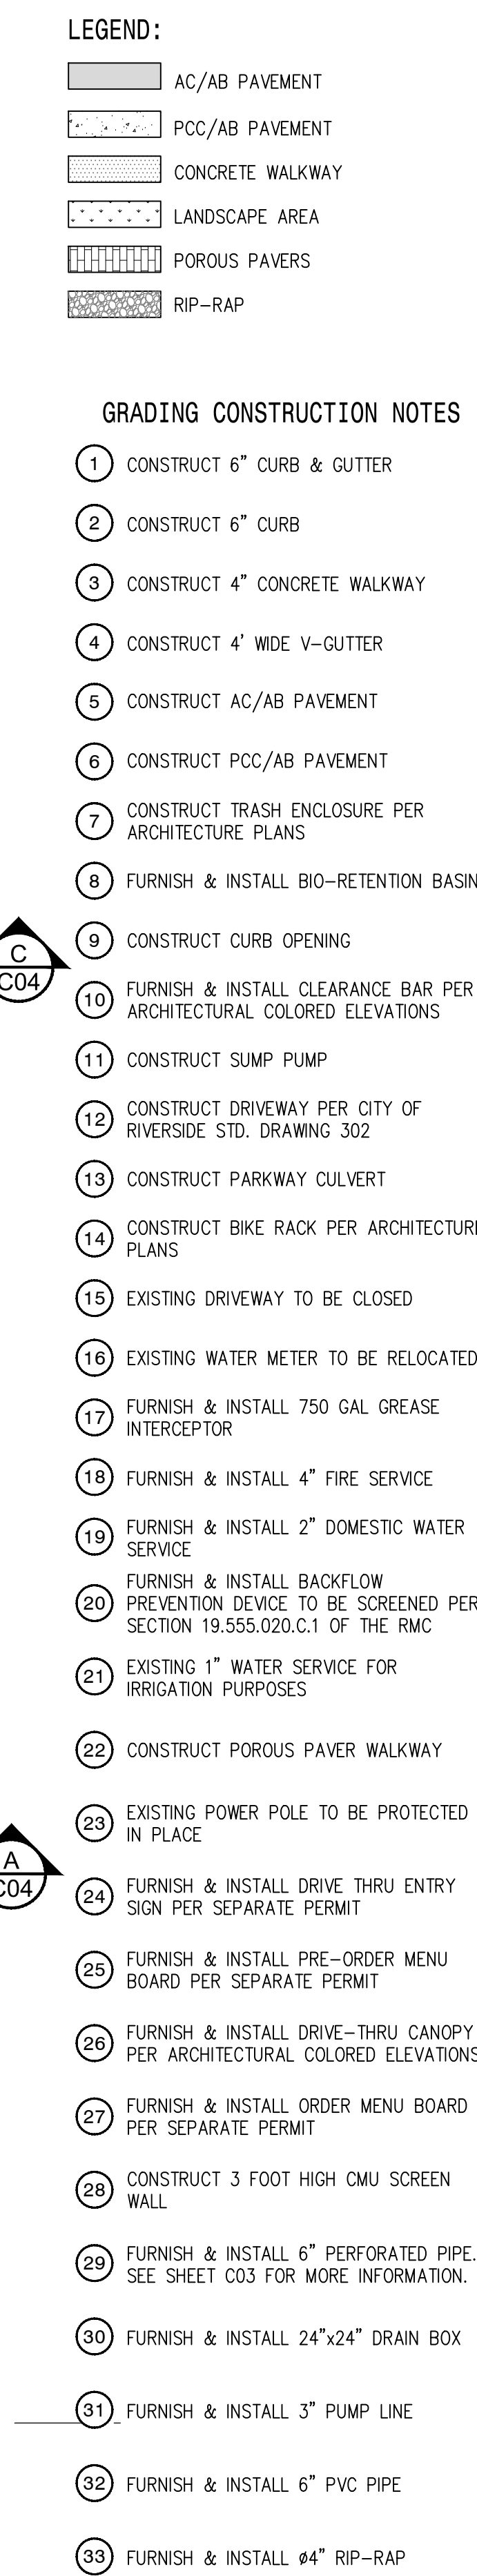

LEGEND:	
	AC/AB PAVEMENT
	PCC/AB PAVEMENT
	CONCRETE WALKWAY
	LANDSCAPE AREA
	POROUS PAVERS
	RIP-RAP
GRADING CONSTRUCTION NOTES	
1	CONSTRUCT 6" CURB & GUTTER
2	CONSTRUCT 6" CURB
3	CONSTRUCT 4" CONCRETE WALKWAY
4	CONSTRUCT 4' WIDE V-GUTTER
5	CONSTRUCT AC/AB PAVEMENT
6	CONSTRUCT PCC/AB PAVEMENT
7	CONSTRUCT TRASH ENCLOSURE PER ARCHITECTURAL PLANS
8	FURNISH & INSTALL BIO-RETENTION BASIN
9	CONSTRUCT CURB OPENING
10	FURNISH & INSTALL CLEARANCE BAR PER ARCHITECTURAL COLORED ELEVATIONS
11	CONSTRUCT SUMP PUMP
12	CONSTRUCT DRIVEWAY PER CITY OF RIVERSIDE STD. DRAWING 302
13	CONSTRUCT PARKWAY CULVERT
14	CONSTRUCT BIKE RACK PER ARCHITECTURAL PLANS
15	EXISTING DRIVEWAY TO BE CLOSED
16	EXISTING WATER METER TO BE RELOCATED
17	FURNISH & INSTALL 750 GAL GREASE INTERCEPTOR
18	FURNISH & INSTALL 4" FIRE SERVICE
19	FURNISH & INSTALL 2" DOMESTIC WATER SERVICE
20	FURNISH & INSTALL BACKFLOW PREVENTION DEVICE TO BE SCREENED PER SECTION 19.555.020.C.1 OF THE RMC
21	EXISTING 1" WATER SERVICE FOR IRRIGATION PURPOSES
22	CONSTRUCT POROUS PAVER WALKWAY
23	EXISTING POWER POLE TO BE PROTECTED IN PLACE
24	FURNISH & INSTALL DRIVE THRU ENTRY SIGN PER SEPARATE PERMIT
25	FURNISH & INSTALL PRE-ORDER MENU BOARD PER SEPARATE PERMIT
26	FURNISH & INSTALL DRIVE-THRU CANOPY PER ARCHITECTURAL COLORED ELEVATIONS
27	FURNISH & INSTALL ORDER MENU BOARD PER SEPARATE PERMIT
28	CONSTRUCT 3 FOOT HIGH CMU SCREEN WALL
29	FURNISH & INSTALL 6" PERFORATED PIPE. SEE SHEET C03 FOR MORE INFORMATION.
30	FURNISH & INSTALL 24"x24" DRAIN BOX
31	FURNISH & INSTALL 3" PUMP LINE
32	FURNISH & INSTALL 6" PVC PIPE
33	FURNISH & INSTALL Ø4" RIP-RAP

CONCEPTUAL GRADING PLAN

POLLO CAMPERO

11095 MAGNOLIA AVENUE

RIVERSIDE, CA

JOB NO. 2205041

DATE: 3/31/2023

SHEET

3/31/2023

DATE



Polo Campero Inc.
 PLUMP ENGINEERING INC.
 CONSULTING ENGINEERS IN
 CIVIL/STRUCTURAL
 ENGINEERING & SURVEYING
 904 E. KATHLEEN AVENUE
 RIVERSIDE, CA 92508
 (714) 382-1835, FAX (714) 385-1834

3/31/2023

DATE



PROFESSIONAL ENGINEER
 TYRONE A. TREVIÑO
 NO. 69889
 EX-1231123
 CIVIL
 STATE OF CALIFORNIA

3/31/2023

DATE

PLUMP ENGINEERING INC.

CONSULTING ENGINEERS IN

CIVIL/STRUCTURAL

ENGINEERING & SURVEYING

904 E. KATHLEEN AVENUE

RIVERSIDE, CA 92508

(714) 382-1835, FAX (714) 385-1834

3/31/2023

DATE

PLUMP ENGINEERING INC.

CONSULTING ENGINEERS IN

CIVIL/STRUCTURAL

ENGINEERING & SURVEYING

904 E. KATHLEEN AVENUE

RIVERSIDE, CA 92508

(714) 382-1835, FAX (714) 385-1834

3/31/2023

DATE

PLUMP ENGINEERING INC.

CONSULTING ENGINEERS IN

CIVIL/STRUCTURAL

ENGINEERING & SURVEYING

904 E. KATHLEEN AVENUE

RIVERSIDE, CA 92508

(714) 382-1835, FAX (714) 385-1834

3/31/2023

DATE

PLUMP ENGINEERING INC.

CONSULTING ENGINEERS IN

CIVIL/STRUCTURAL

ENGINEERING & SURVEYING

904 E. KATHLEEN AVENUE

RIVERSIDE, CA 92508

(714) 382-1835, FAX (714) 385-1834

3/31/2023

DATE

PLUMP ENGINEERING INC.

CONSULTING ENGINEERS IN

CIVIL/STRUCTURAL

ENGINEERING & SURVEYING

904 E. KATHLEEN AVENUE

RIVERSIDE, CA 92508

(714) 382-1835, FAX (714) 385-1834

3/31/2023

DATE

PLUMP ENGINEERING INC.

CONSULTING ENGINEERS IN

CIVIL/STRUCTURAL

ENGINEERING & SURVEYING

904 E. KATHLEEN AVENUE

RIVERSIDE, CA 92508

(714) 382-1835, FAX (714) 385-1834

3/31/2023

DATE

PLUMP ENGINEERING INC.

CONSULTING ENGINEERS IN

CIVIL/STRUCTURAL

ENGINEERING & SURVEYING

904 E. KATHLEEN AVENUE

RIVERSIDE, CA 92508

(714) 382-1835, FAX (714) 385-1834

3/31/2023

DATE

PLUMP ENGINEERING INC.

CONSULTING ENGINEERS IN

CIVIL/STRUCTURAL

ENGINEERING & SURVEYING

904 E. KATHLEEN AVENUE

RIVERSIDE, CA 92508

(714) 382-1835, FAX (714) 385-1834

3/31/2023

DATE

PLUMP ENGINEERING INC.

CONSULTING ENGINEERS IN

CIVIL/STRUCTURAL

ENGINEERING & SURVEYING

904 E. KATHLEEN AVENUE

RIVERSIDE, CA 92508

(714) 382-1835, FAX (714) 385-1834

3/31/2023

DATE

PLUMP ENGINEERING INC.

CONSULTING ENGINEERS IN

CIVIL/STRUCTURAL

ENGINEERING & SURVEYING

904 E. KATHLEEN AVENUE

RIVERSIDE, CA 92508

(714) 382-1835, FAX (714) 385-1834

3/31/2023

DATE

PLUMP ENGINEERING INC.

CONSULTING ENGINEERS IN

CIVIL/STRUCTURAL

ENGINEERING & SURVEYING

904 E. KATHLEEN AVENUE

RIVERSIDE, CA 92508

(714) 382-1835, FAX (714) 385-1834

3/31/2023

DATE

PLUMP ENGINEERING INC.

CONSULTING ENGINEERS IN

CIVIL/STRUCTURAL

ENGINEERING & SURVEYING

904 E. KATHLEEN AVENUE

RIVERSIDE, CA 92508

(714) 382-1835, FAX (714) 385-1834

3/31/2023

DATE

PLUMP ENGINEERING INC.

CONSULTING ENGINEERS IN

CIVIL/STRUCTURAL

ENGINEERING & SURVEYING

904 E. KATHLEEN AVENUE

RIVERSIDE, CA 92508

(714) 382-1835, FAX (714) 385-1834

3/31/2023

DATE

PLUMP ENGINEERING INC.

CONSULTING ENGINEERS IN

CIVIL/STRUCTURAL

ENGINEERING & SURVEYING

904 E. KATHLEEN AVENUE

RIVERSIDE, CA 92508

(714) 382-1835, FAX (714) 385-1834

3/31/2023

DATE

PLUMP ENGINEERING INC.

CONSULTING ENGINEERS IN

CIVIL/STRUCTURAL

ENGINEERING & SURVEYING

904 E. KATHLEEN AVENUE

RIVERSIDE, CA 92508

(714) 382-1835, FAX (714) 385-1834

3/31/2023

DATE

PLUMP ENGINEERING INC.

CONSULTING ENGINEERS IN

CIVIL/STRUCTURAL

ENGINEERING & SURVEYING

904 E. KATHLEEN AVENUE

RIVERSIDE, CA 92508

(714) 382-1835, FAX (714) 385-1834

3/31/2023

DATE

PLUMP ENGINEERING INC.

CONSULTING ENGINEERS IN

CIVIL/STRUCTURAL






ENGINEERING & SURVEYING

904 E. KATHLEEN AVENUE

RIVERSIDE, CA 92508

(714) 382-1835, FAX (714) 385-1834

3/31/2023

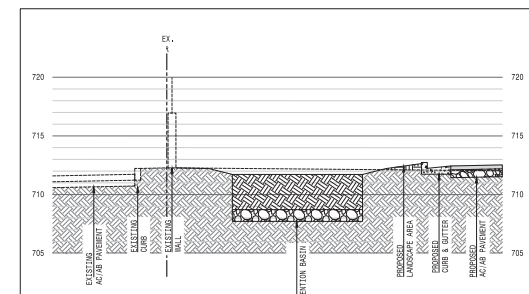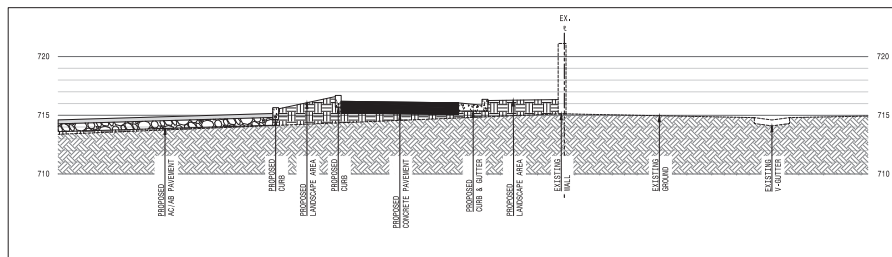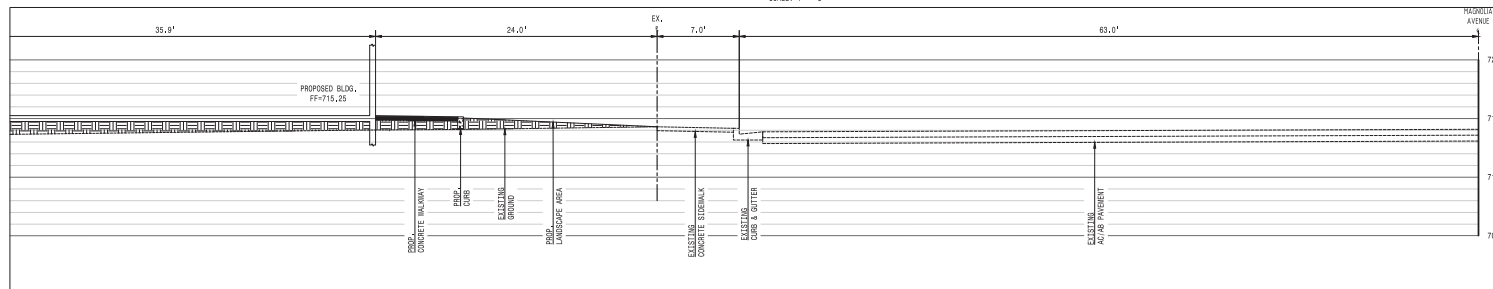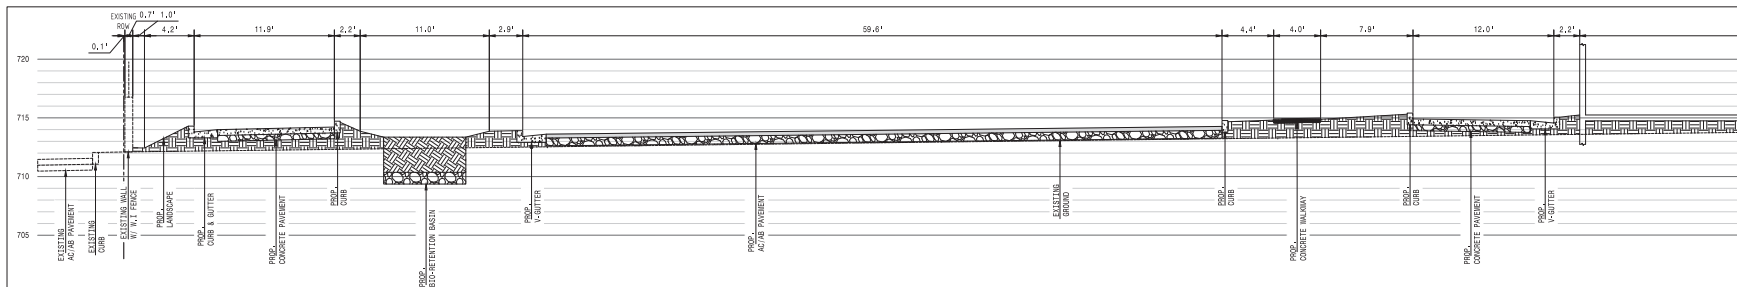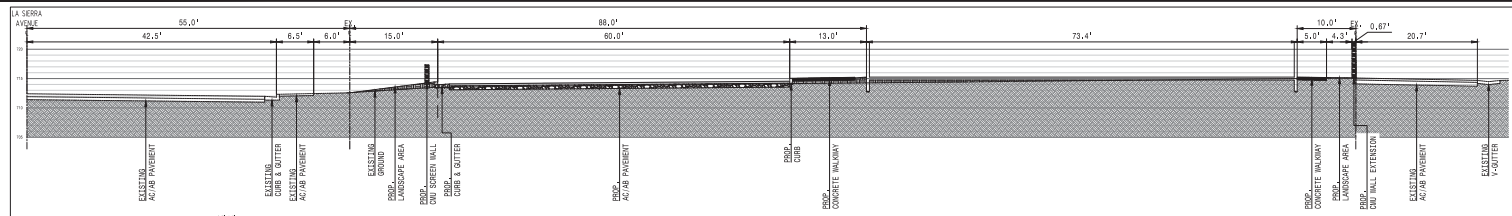

C04

[illegible]


PLUMP ENGINEERING INC.
CONSULTING ENGINEERS IN
CIVIL/STRUCTURAL
ENGINEERING & SURVEYING
1100 E. KATELLA AVENUE
SUITE 100
DENVER, CO 80202
(303) 733-1100

SITE SECTIONS
POLLO CAMPERO
11095 MAGNOLIA AVENUE

JOB NO. 2205041
DATE: 1/31/2023
SHEET 4 OF 6 SHEETS



FENCE AND WALL PLAN POLLO CAMPERO 11095 MAGNOLIA AVENUE		RIVERSIDE, CA	
JOB NO. 2205041			
DATE: 3/31/2023			
SHEET			
5 OF 6 SHEETS			

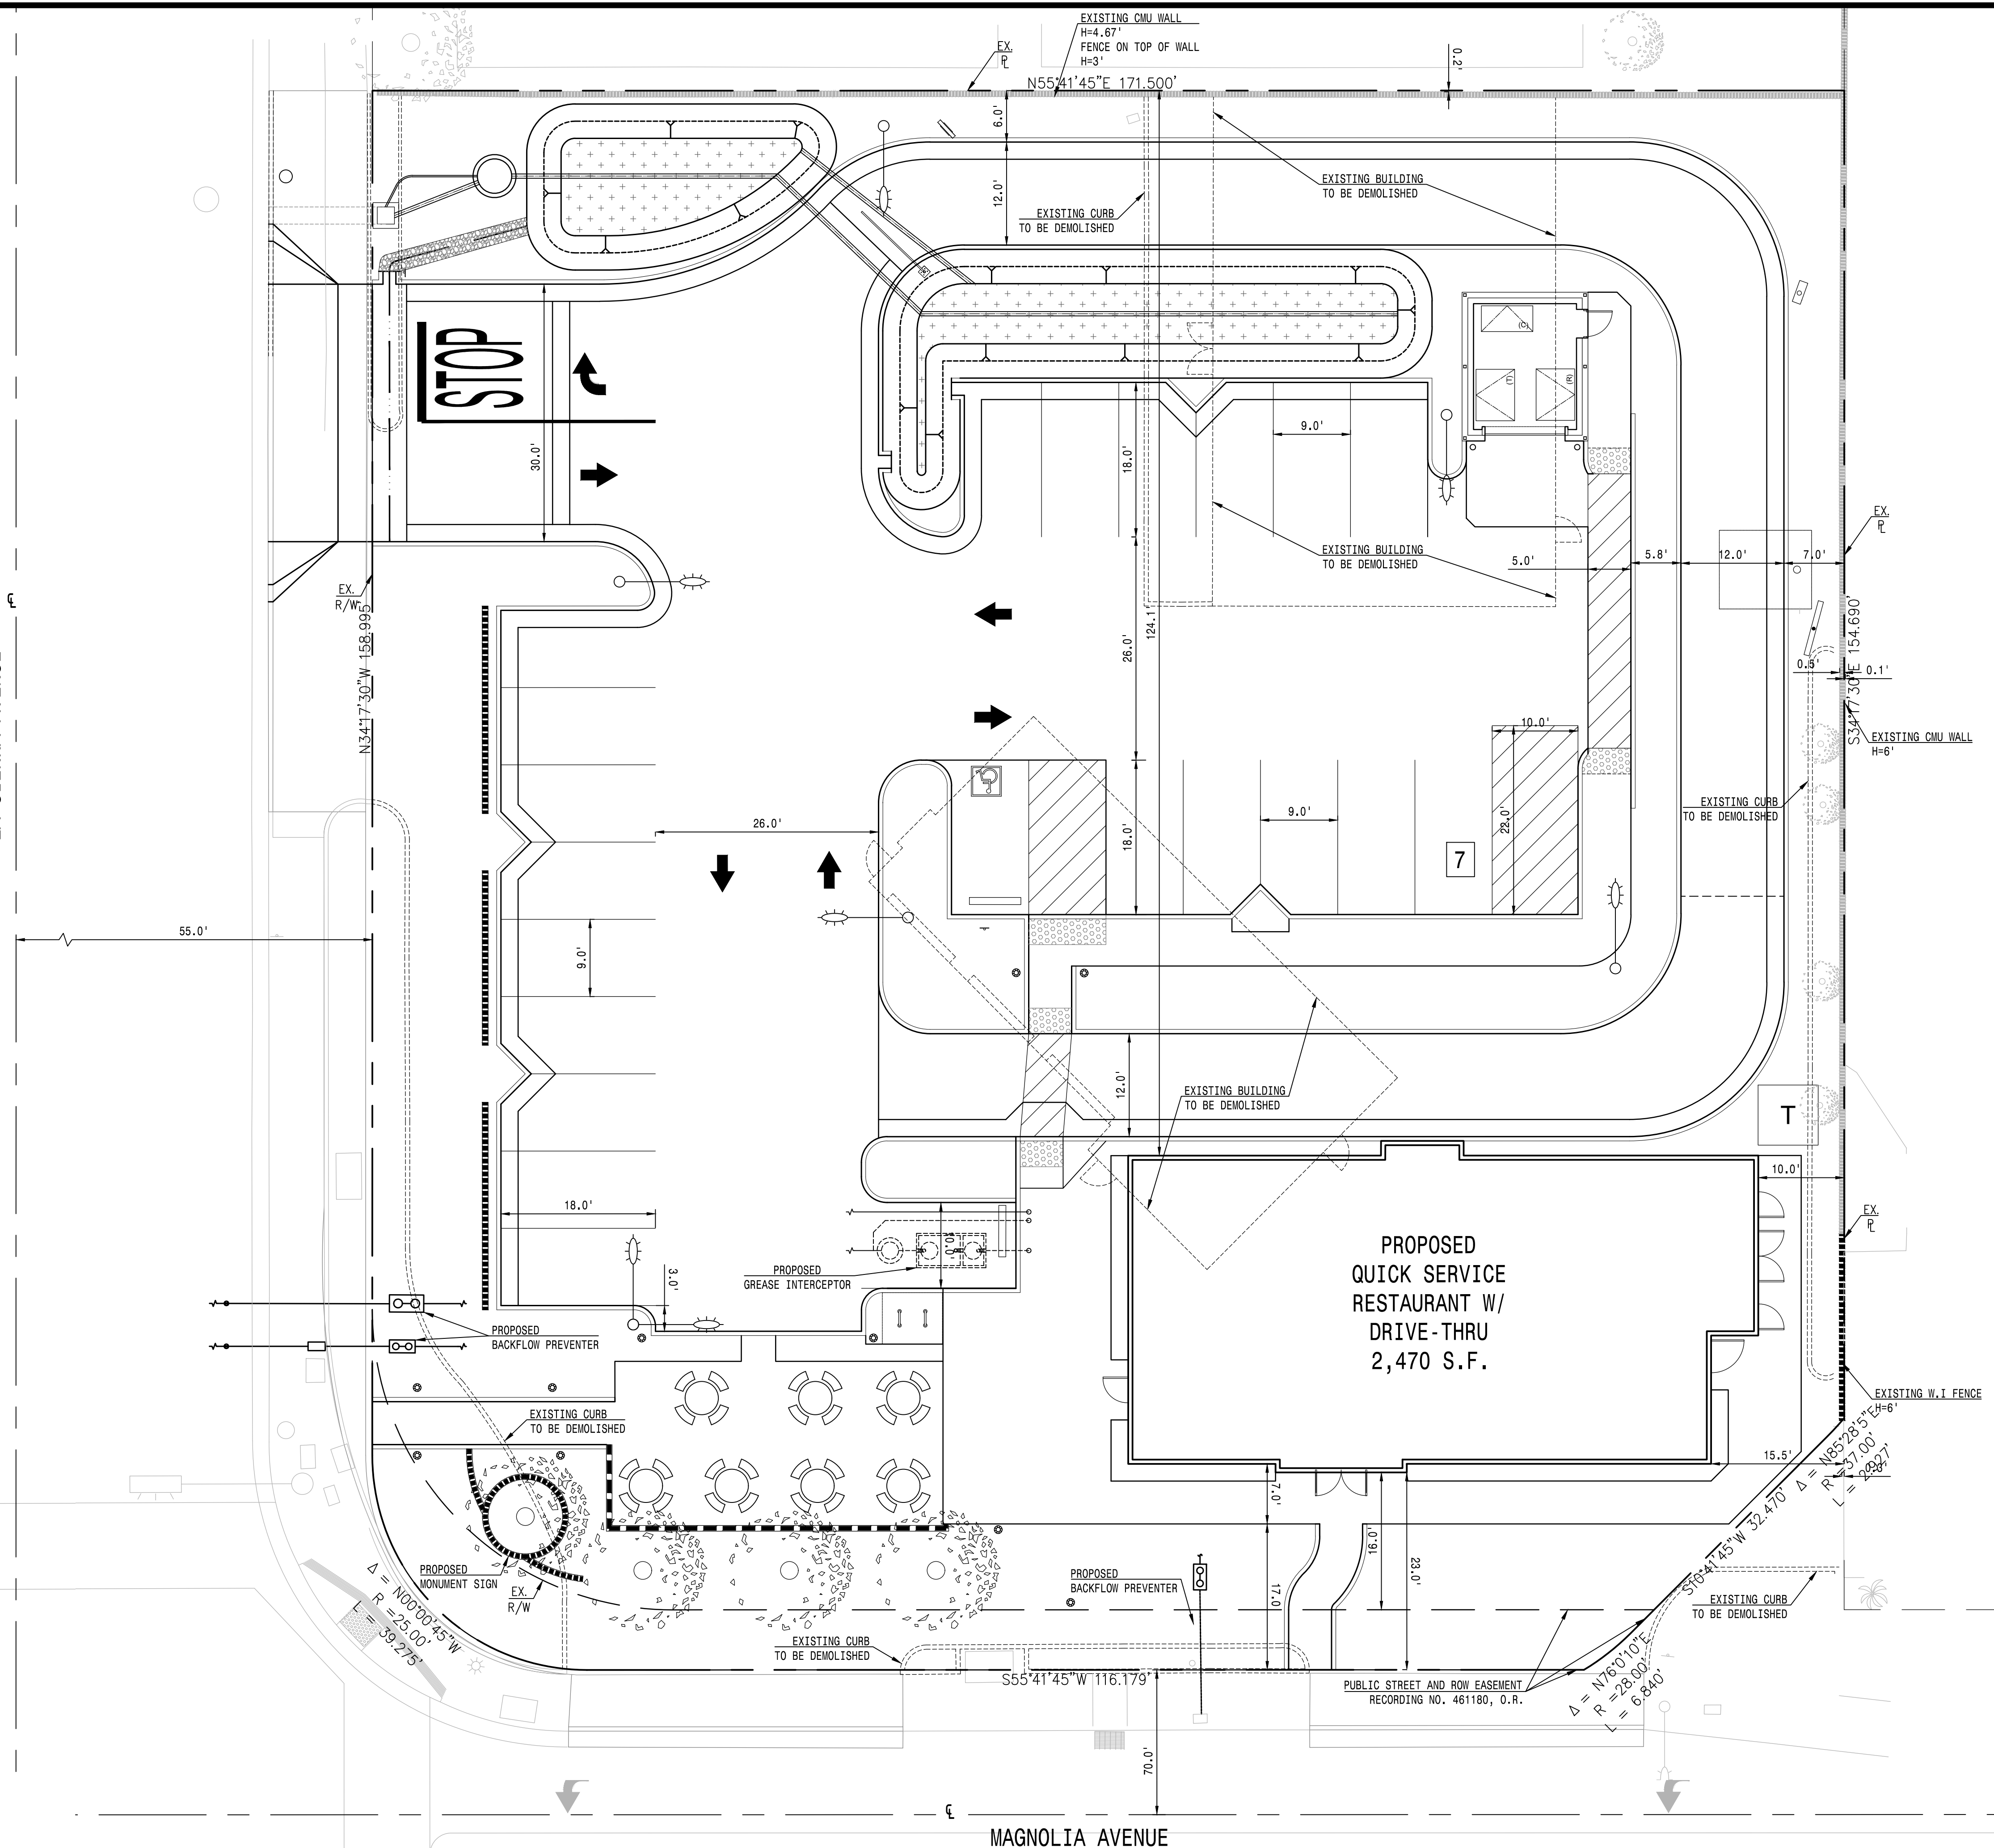[illegible]

pump
ENGINEERING INC.


**PUMP ENGINEERING INC.,
CONSULTING ENGINEERS IN
CIVIL / STRUCTURAL
ENGINEERING & SURVEYING**

AN ANGELIC CALIFORNIA COMPANY
PUMP ENGINEERING INC. (714) 385-1835 FAX (714) 385-1834

RYAN TRIVANDRANILLOS

JOB NO.
2205041
DATE: **3/31/2023**
SHEET
6 OF 6 SHEETS

THESE DRAWINGS AND SPECIFICATIONS ARE THE PROPERTY OF THE BUREAU OF ENGINEERING, INC. NO PART OF THESE DRAWINGS INCLUDING DESIGN CONCEPT MAY BE USED, REPRODUCED OR TRANSMITTED IN ANY FORM OR BY ANY MEANS, ELECTRONIC OR MECHANICAL, WITHOUT PERMISSION IN WRITING FROM THE BUREAU OF ENGINEERING, INC.

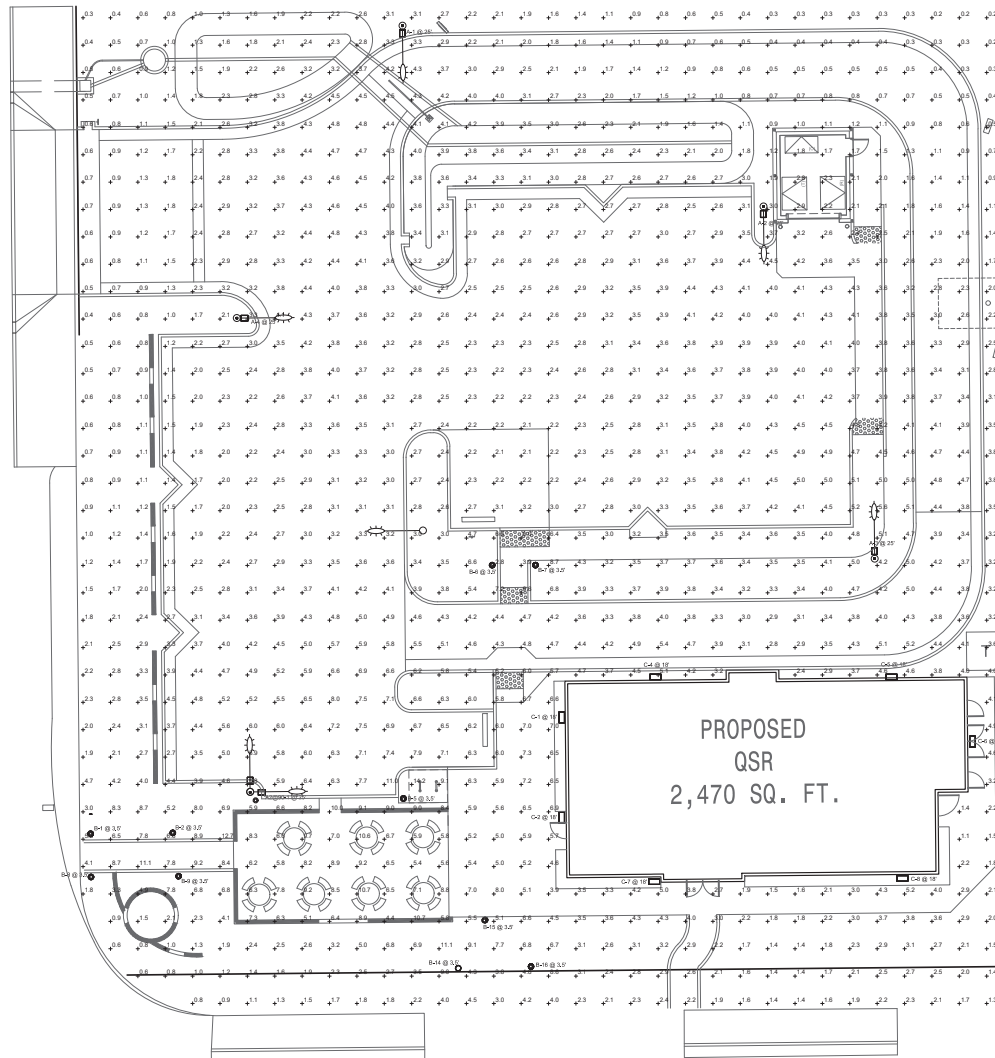

Schedule									
Symbol	Label	QTY	Manufacturer	Catalog	Description	Number Lamps	Lamp Output	LLF	Foot Candle
	A	4	Lithonia Lighting	ESX1 LED P2 40K R3	Controler Rated ESX LED Area Luminare Size 1 P2 Lumen Package 4000K CCT Type R3 Distribution	1	13917	0.9	97.59
	A2@ 90	1	Lithonia Lighting	ESX1 LED P2 40K R3	Controler Rated ESX LED Area Luminare Size 1 P2 Lumen Package 4000K CCT Type R3 Distribution	1	13917	0.9	125.16
	B	16	Lithonia Lighting	NBC8 LED 13C 350 40K ASYM MCHLT	NBC8 WITH 3 LIGHT BOWARDS (12 LED), 3500K DRIVER, 4000K COLOR TEMP, AND ASYMMETRIC OPTIC	1	909	0.9	16
	C	7	Lithonia Lighting	FWX2 LED ALD 40K	FWX2 LED WITH ALD - PERFORMANCE PACKAGE, 4000K	1	8942	0.9	53.8994

Statistics						
Description	Symbol	Avg	Max	Min	MaxMin	AvgMin
SITE	+	3.4 fc	14.2 fc	0.2 fc	71.0 f	17.0 f

E200

NO	DATE	REVISION DESCRIPTION	APPRO	DATE




PLUMP ENGINEERING INC.
CONSULTING ENGINEERS IN
CIVIL/STRUCTURAL
ENGINEERING & SURVEYING
11095 MAGNOLIA AVENUE
RIVERSIDE, CA 92504
951-500-1000

SITE PHOTOMETRIC PLAN
POLLO CAMPERO
11095 MAGNOLIA AVENUE
RIVERSIDE, CA

JOB NO. 2205041
DATE: 2/3/2023
SHEET 1 OF 1 SHEETS



SITE PHOTOMETRIC PLAN 1 NTS

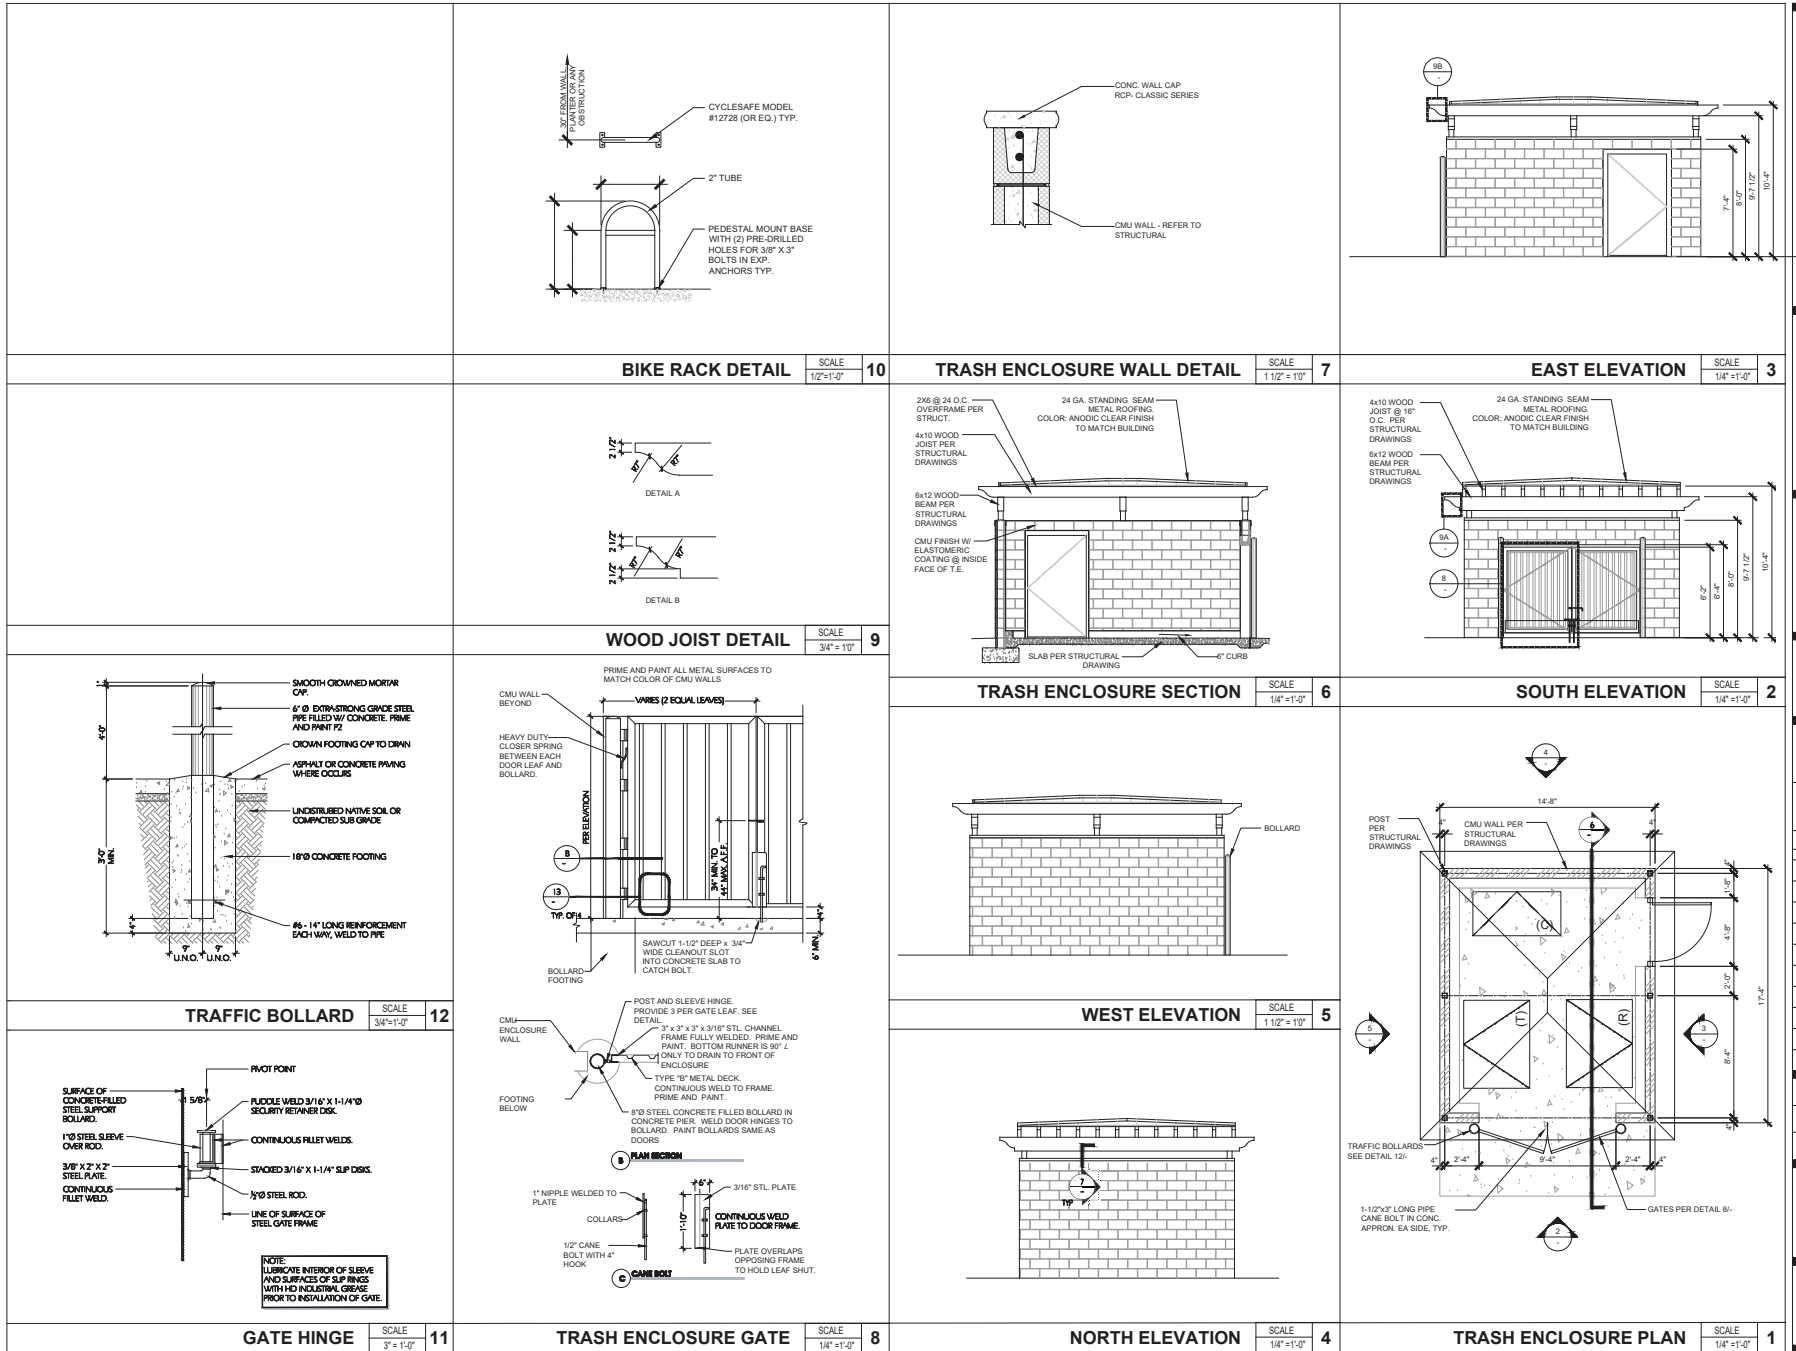

CONSULTANT:

PM DESIGN
Architectural Solutions Group

38 EXECUTIVE PARK
Suite 310
IRVINE, CA 92614

STAMP:

PROJECT OWNER:

CAMPERO

PROJECT ADDRESS:

11095 MAGNOLIA AVE.,
RIVERSIDE, CA

ISSUE FOR DESCRIPTION:

2nd PLANNING SUBMITTAL

ISSUE DATE:

11/23/2022

REVISIONS:

NO.	DESCRIPTION	DATE
1ST PLANNING SUBMITTAL		09/09/2022
2ND PLANNING SUBMITTAL		11/23/2022


PROJECT MANAGER:
VANDANA KULKAR

DRAWN BY:
N.P.

PROJECT NUMBER: PCC21007.0


SHEET TITLE:
TRASH ENCLOSURE DETAILS

SHEET NUMBER:
A0.2

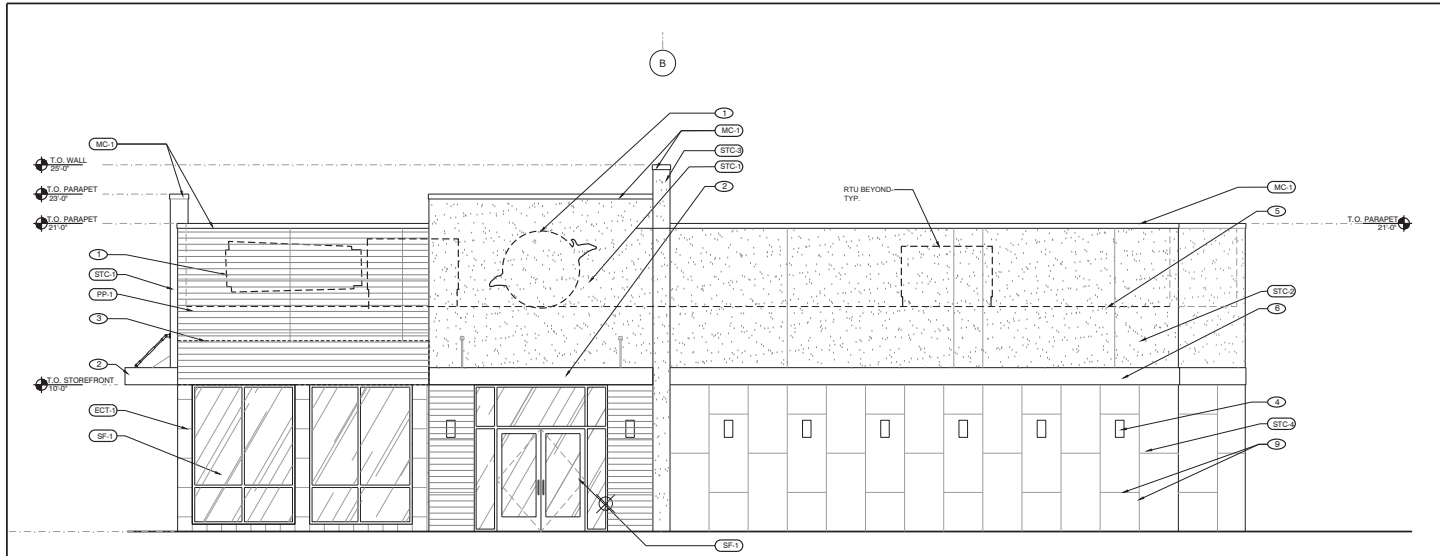


SOUTH ELEVATION

SCALE
1/4" = 1'-0" **1**

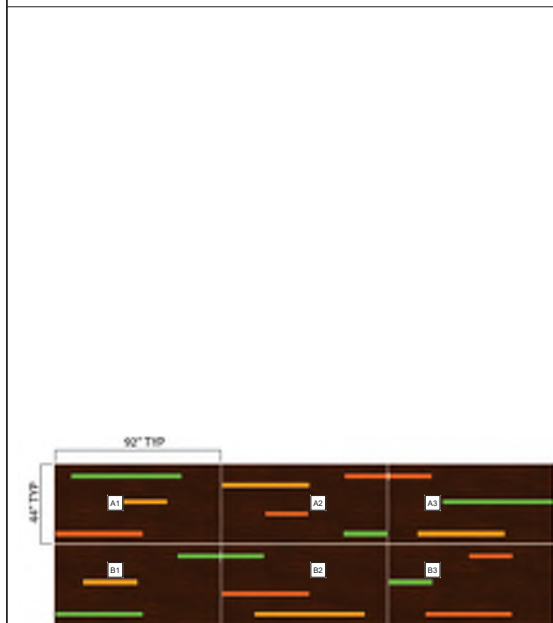

ACM PANEL PP-1 GRAPHIC LAYOUT

SCALE
N.T.S. **3**

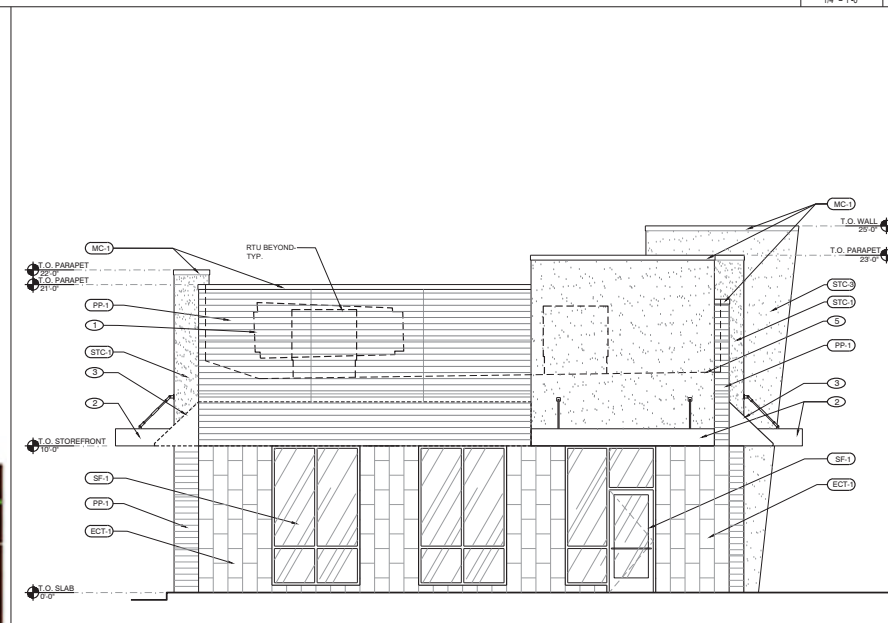

WEST ELEVATION

SCALE
1/4" = 1'-0" **2**

KEYNOTES

1. APPROXIMATE LOCATION FOR SIGNAGE BY SIGNAGE VENDOR (UNDER SEPARATE PERMIT)
2. STL CANOPY
3. ALUMINUM AWNING BY SIGNAGE VENDOR
4. EXTERIOR WALL MOUNTED LIGHT FIXTURE, REF. ELEC. DRAWINGS FOR SPEC.
5. LINE OF ROOF DECK BEYOND
6. ALUMINUM BAND, REF. DETAIL 06/AB.6
7. DOWNSPOUT NOZZLE, REF. DETAIL 08/AB.8
8. DRIVE THRU WINDOW, REF. WINDOW SCHEDULE ON SHEET A7.9
9. STUCCO CONTROL JOINT

EXTERIOR FINISHES

C#	DESCRIPTION
EXTERIOR STUCCO PAINT	
STC-1	MANUFACTURER: STO CORP. PRODUCT / FINISH: STUCCO, POWERWALL OR EQ. COLOR: FINISH: SHERWIN WILLIAMS - SW 0885 KNOCKOUT ORANGE, EGGSHELL NOTES: PRIME AND 2 FINISH COATS
STC-2	MANUFACTURER: STO CORP. PRODUCT / FINISH: STUCCO, POWERWALL OR EQ. COLOR: FINISH: SHERWIN WILLIAMS - SW 2696 FAIRFAX BROWN NOTES: PRIME AND 2 FINISH COATS
STC-3	MANUFACTURER: STO CORP. PRODUCT / FINISH: STUCCO, POWERWALL OR EQ. COLOR: FINISH: SHERWIN WILLIAMS - SW 6705 HIGH STRUNG NOTES: PRIME AND 2 FINISH COATS
STC-4	MANUFACTURER: STO CORP. PRODUCT / FINISH: STUCCO, POWERWALL OR EQ. COLOR: FINISH: SHERWIN WILLIAMS - SW 9110 MALABAR NOTES: PRIME AND 2 FINISH COATS
TILE	
ECT-1	MANUFACTURER: DALTILE PRODUCT / FINISH: PORCELAIN 12X24 COLOR: EV02
COPING	
MC-1	PRODUCT / FINISH: MTL COPING COLOR: ANODIC CLEAR FINISH (METALLIC) PROFILE: TAPERED PROFILE
METAL PANELING	
ST-1	PRODUCT / FINISH: METAL PANELING COLOR: POLISHED ALUMINUM ALUMINUM COMPOSITE PANELS
PP-1	MANUF.: GENERAL THEMING PRODUCT / FINISH: ALUMINUM COMPOSITE PANELING COLOR: COUNTRY: WOOD WITH LIME, GREEN, YELLOW GOLD, & RED ORANGE ACCENTS
STOREFRONT	
SF-1	PRODUCT / FINISH: CLEAR ANODIZED ALUMINUM, KAWNER OR EQ.

CONSULTANT:



38 EXECUTIVE PARK
Suite 310
IRVINE, CA 92614

STAMP:

PROJECT OWNER:



PROJECT ADDRESS:

11095 MAGNOLIA AVE.,
RIVERSIDE, CA

ISSUE FOR DESCRIPTION:

3RD PLANNING SUBMITTAL

ISSUE DATE:

1/31/2023

REVISIONS:

NO.	DESCRIPTION	DATE
1ST	PLANNING SUBMITTAL	09/09/2022
2ND	PLANNING SUBMITTAL	11/23/2022
3RD	PLANNING SUBMITTAL	01/31/2023

PROJECT MANAGER:

VANDANA KELKAR

DRAWN BY:

W.P.


PROJECT NUMBER: PCC21007.0

SHEET TITLE:

**EXTERIOR
ELEVATIONS**

SHEET NUMBER:

A2.0

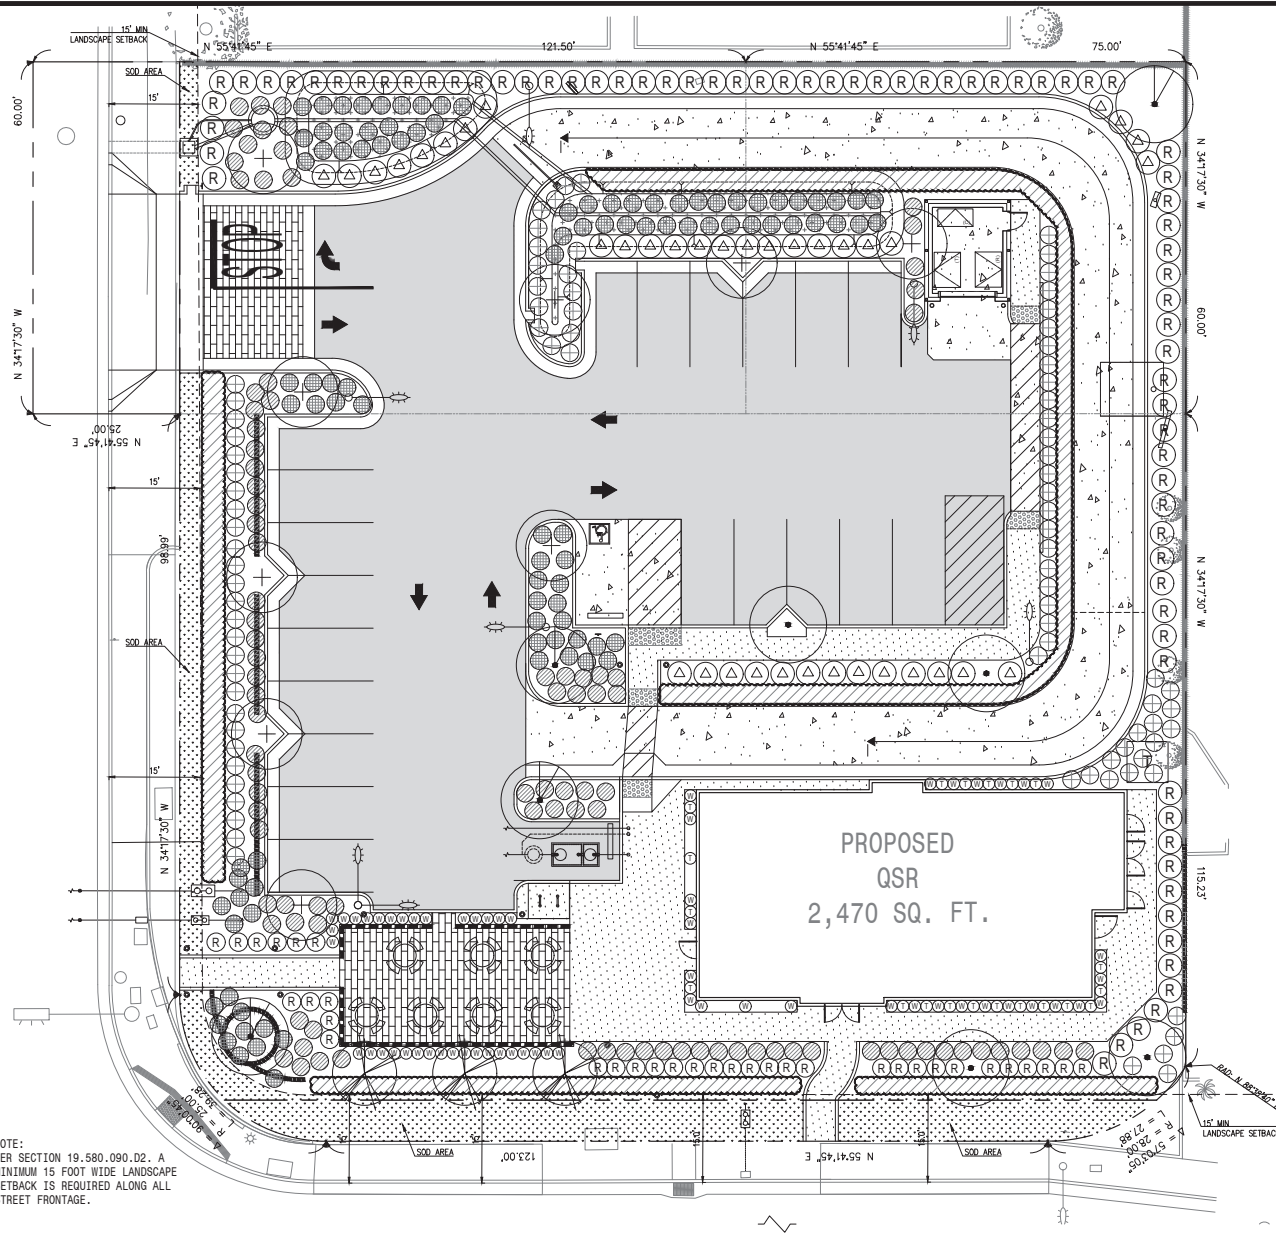

TREE LEGEND

SYMBOL	BOTANICAL/COMMON NAME	SIZE	COMMENTS	WUCOLS
+	PLATANUS RACEMOSA CALIFORNIA SYCAMORE	24" BOX	D.S. STD.	MEDIUM
+	CHLOPSIS LINEARIS DESERT WILLOW	24" BOX	D.S. STD.	MEDIUM
+	UMBELLULARIA CALIFORNICA CALIFORNIA BAY LAUREL	24" BOX	D.S. STD, WOOD	MEDIUM
+	ULMUS PARAFOLIA "DRAKE" DRAKE CHINESE ELM	24" BOX	D.S. STD, WOOD	MEDIUM

SHRUB LEGEND

SYMBOL	BOTANICAL/COMMON NAME	SIZE	COMMENTS	WUCOLS
+	IVA HAYESIANA HAYES IVA	5 GAL	5'-0" O.C.	LOW
+	ROSA CALIFORNICA CALIFORNIA WILD ROSE	5 GAL	5'-0" O.C.	LOW
+	WESTRINGIA F. "BLUE GEM" COAST ROSEMARY	5 GAL	5'-0" O.C.	LOW
+	LIQUSTRUM JAPONICUM "TEXANUM" TEXAS PRIVET	5 GAL	5'-0" O.C.	LOW
+	CEONOTHUS GRISEUS "SANTA ANA" (HEDGE) SANTA ANA CEONOTHUS	5 GAL	6'-0" O.C.	LOW

GROUND COVER LEGEND

SYMBOL	BOTANICAL/COMMON NAME	SIZE	COMMENTS	WUCOLS
+	MUEHLBERGIA PIGENS DEERGRASS	1 GAL	5'-0" O.C.	LOW
+	BACCHARIS PILLULARIS "PIGEON POINT" DWARF COYOTE BUSH	1 GAL	4'-0" O.C.	LOW
+	CEONOTHUS "ANCHOR BAY" ANCHOR BAY CEONOTHUS	1 GAL	4'-0" O.C.	LOW

ROCK MULCH LEGEND

APPLY A 2" DEEP LAYER OF 3/4" SCREENED ROCK MULCH IN ALL PLANTING AREAS. TOP OF ROCK MULCH SHALL BE 1" BELOW FINISH SURFACE OF ADJACENT PAVING.

ROCK MULCH ALL PLANTING AREAS

- NOTES**
- USE ROOT BARRIERS FOR ALL TREES WITHIN 10' OF A CONCRETE CURB.
 - A 1 YEAR LANDSCAPE MAINTENANCE PERIOD AND 1 YEAR WARRANTY IS REQUIRED FOR ALL PLANTING AND IRRIGATION.

LEGEND:

+	AC/AB PAVEMENT
+	PCC/AB PAVEMENT
+	CONCRETE WALKWAY
+	SOD LANDSCAPE AREA



SCALE: 1" = 10'

L101

NO.	DATE	REVISION DESCRIPTION



PLUMP ENGINEERING INC.
CONSULTING ENGINEERS IN
CIVIL/STRUCTURAL
ENGINEERING & SURVEYING
11085 MAGNOLIA AVENUE
RIVERSIDE, CA 92504



PLANTING PLAN
POLLO CAMPERO
11085 MAGNOLIA AVENUE
RIVERSIDE, CA

JOB NO. **2205041**
DATE: **2/2/2023**
SHEET
2 OF 6 SHEETS

- TS RIVERSIDE, CA TRIVON TRIVONPOLICE

[illegible]

**PLUMP ENGINEERING INC.,
CONSULTING ENGINEERS IN
CIVIL / STRUCTURAL
ENGINEERING & SURVEYING**



PLANT PALLET
POLLO CAMPERO
11095 MAGNOLIA AVENUE

JOB NO.
2205041
DATE: 2/2/2023
SHEET
4 OF 6 SHEETS



MATERIAL LEGEND:



SHERWIN WILLIAM
SW6885
KNOCKOUT ORANGE



SHERWIN WILLIAM
SW2586
FAIRFAX BROWN



SHERWIN WILLIAM
SW9110
MALABAR



DALTILE EVO2 LIGHT



PRC-CLAD ANODIC CLEAR



CREATIVE FALETTE INC.
COUNTRY WOOD w/ COLOR ACCENTS



SHERWIN WILLIAM
SW6785
HIGH STRUNG