



10/17/2024 3:32:27 PM
Autodesk Docs://246459.00 Pacific Grove Acute Psych Plan/246459.00 Pacific Grove Acute Psych 124.rvt
© BOULDER ASSOCIATES

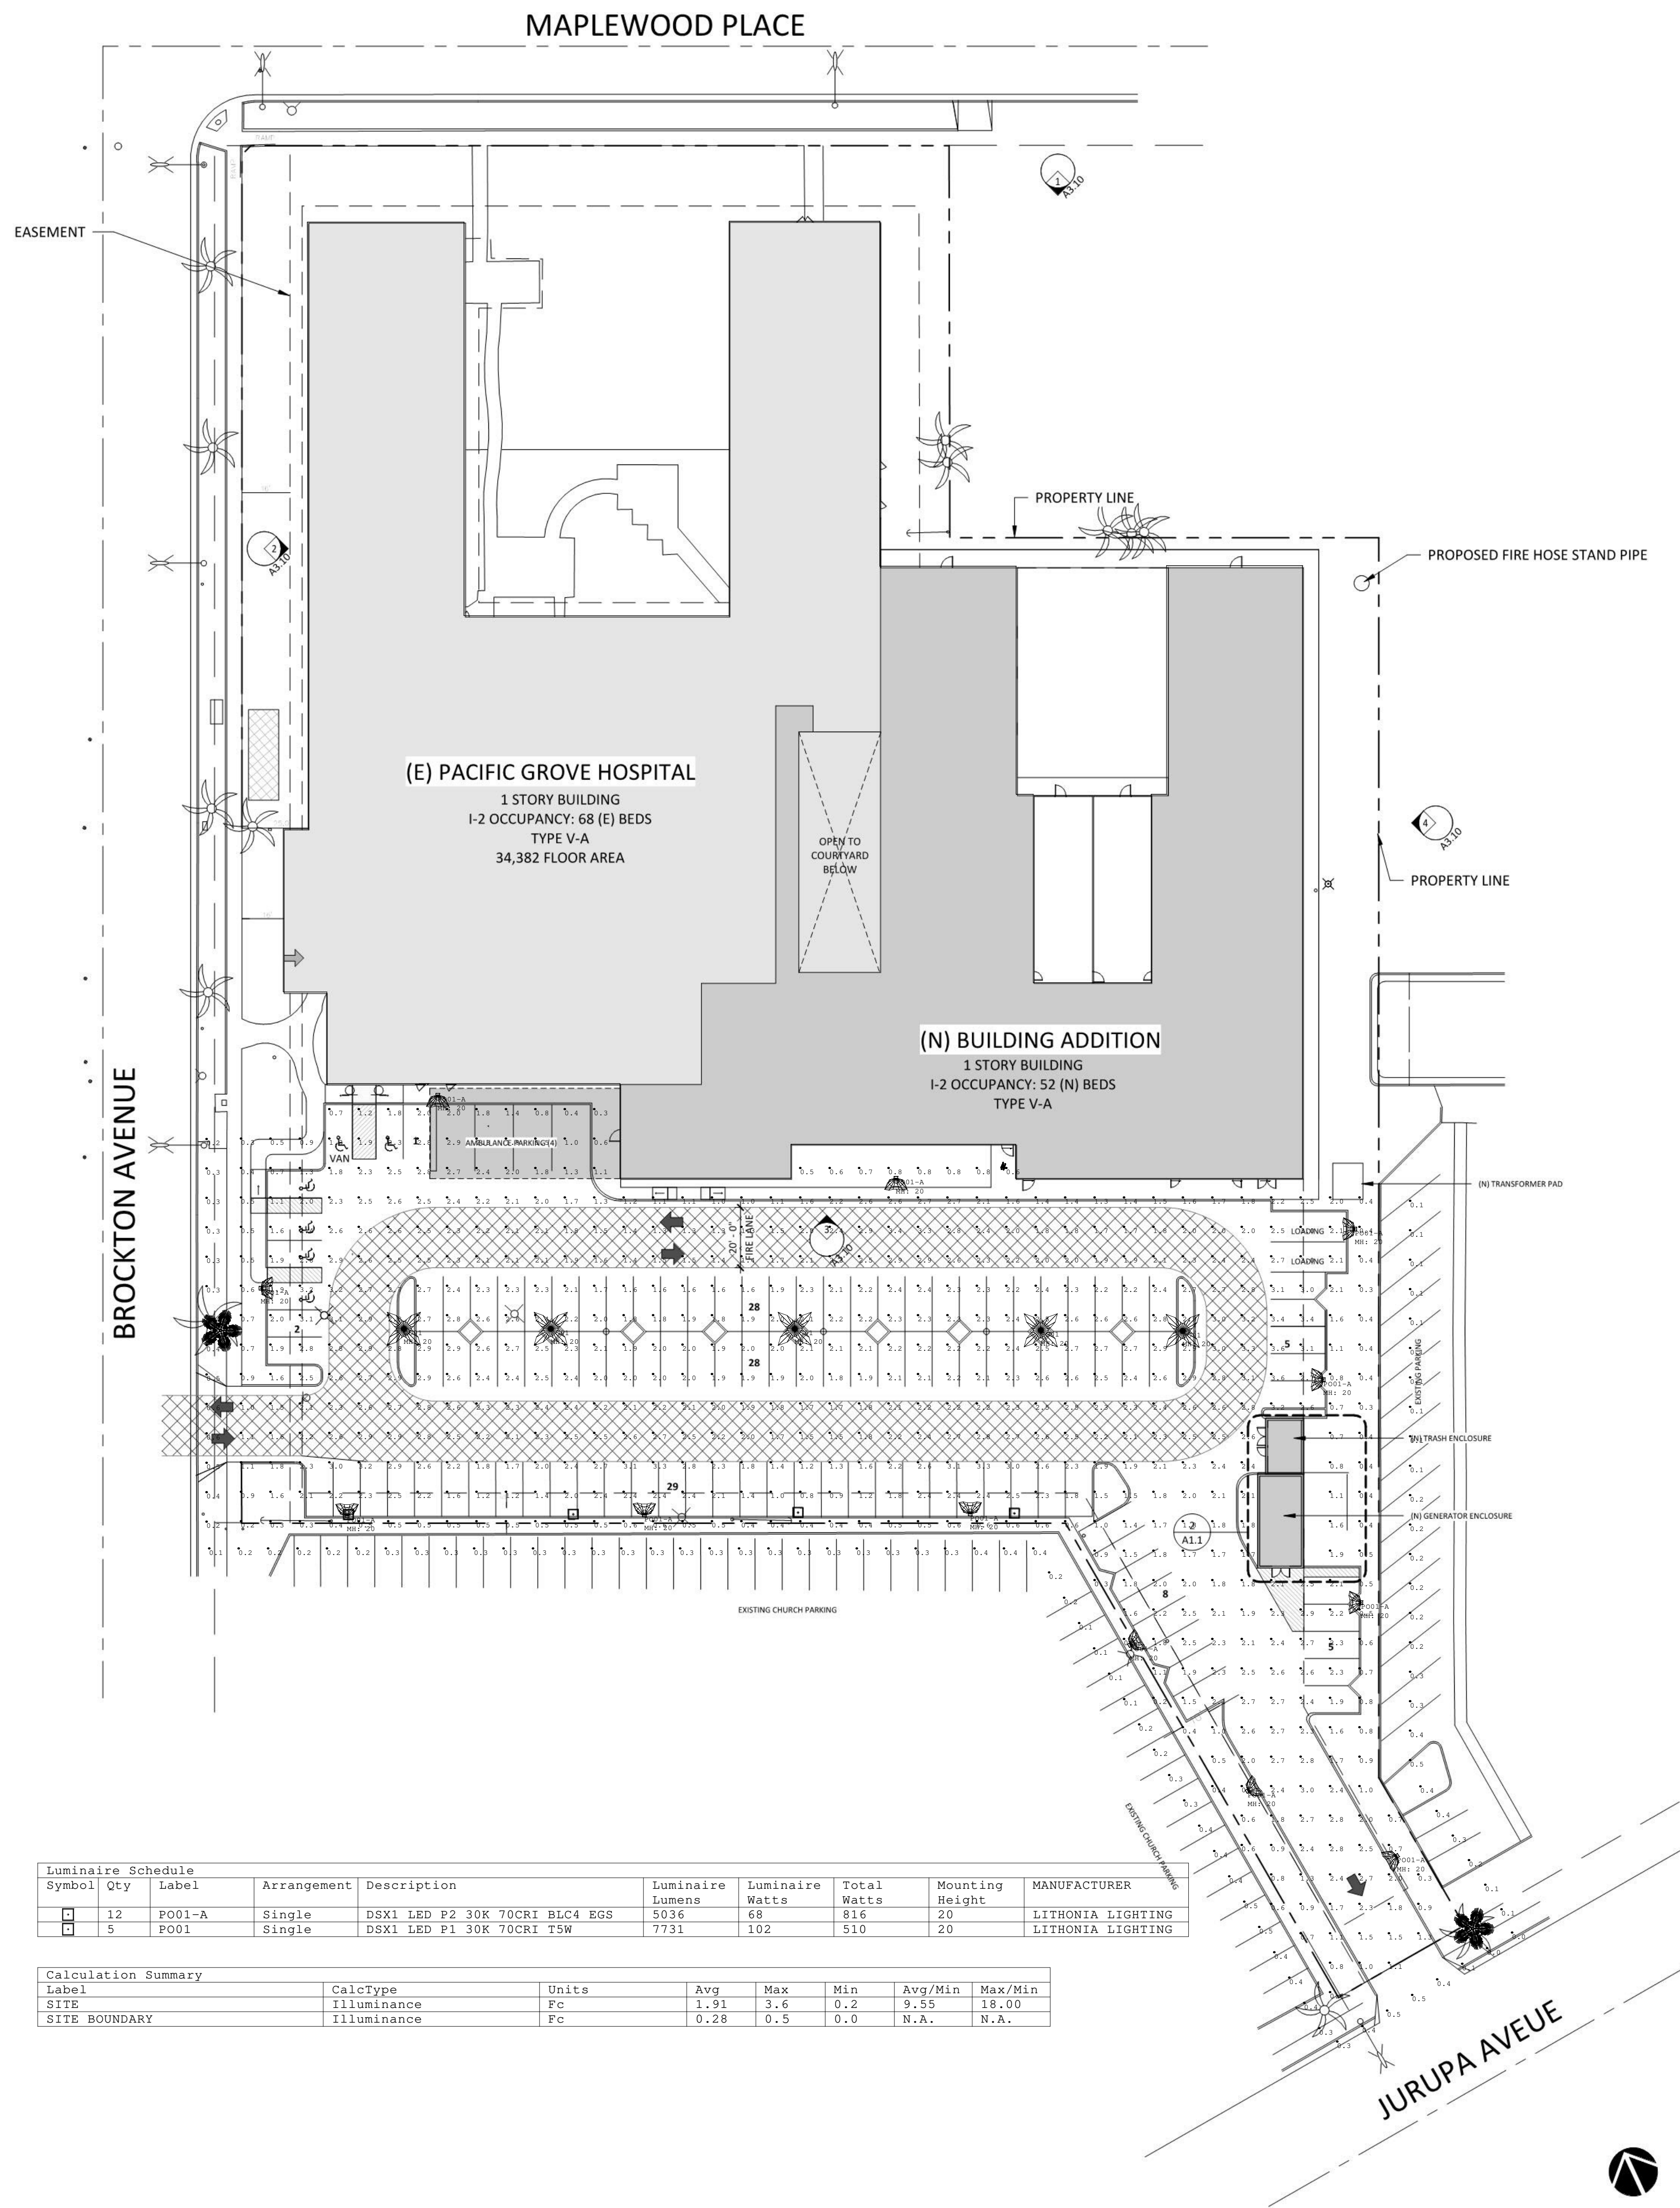

Luminaire Schedule									
Symbol	Qty	Label	Arrangement	Description	Luminaire Lumens	Luminaire Watts	Total Watts	Mounting Height	MANUFACTURER
□	12	P001-A	Single	DSX1 LED P2 30K 70CRI BLC4 EGS	5036	68	816	20	LITHONIA LIGHTING
□	5	P001	Single	DSX1 LED P1 30K 70CRI T5W	7731	102	510	20	LITHONIA LIGHTING

Calculation Summary						
Label	CalcType	Units	Avg	Max	Min	Avg/Min Max/Min
SITE	Illuminance	Fc	1.91	3.6	0.2	9.55 18.00
SITE BOUNDARY	Illuminance	Fc	0.28	0.5	0.0	N.A. N.A.

1 SITE PLAN - PROPOSED SITE
A1.1 1" = 30'-0"

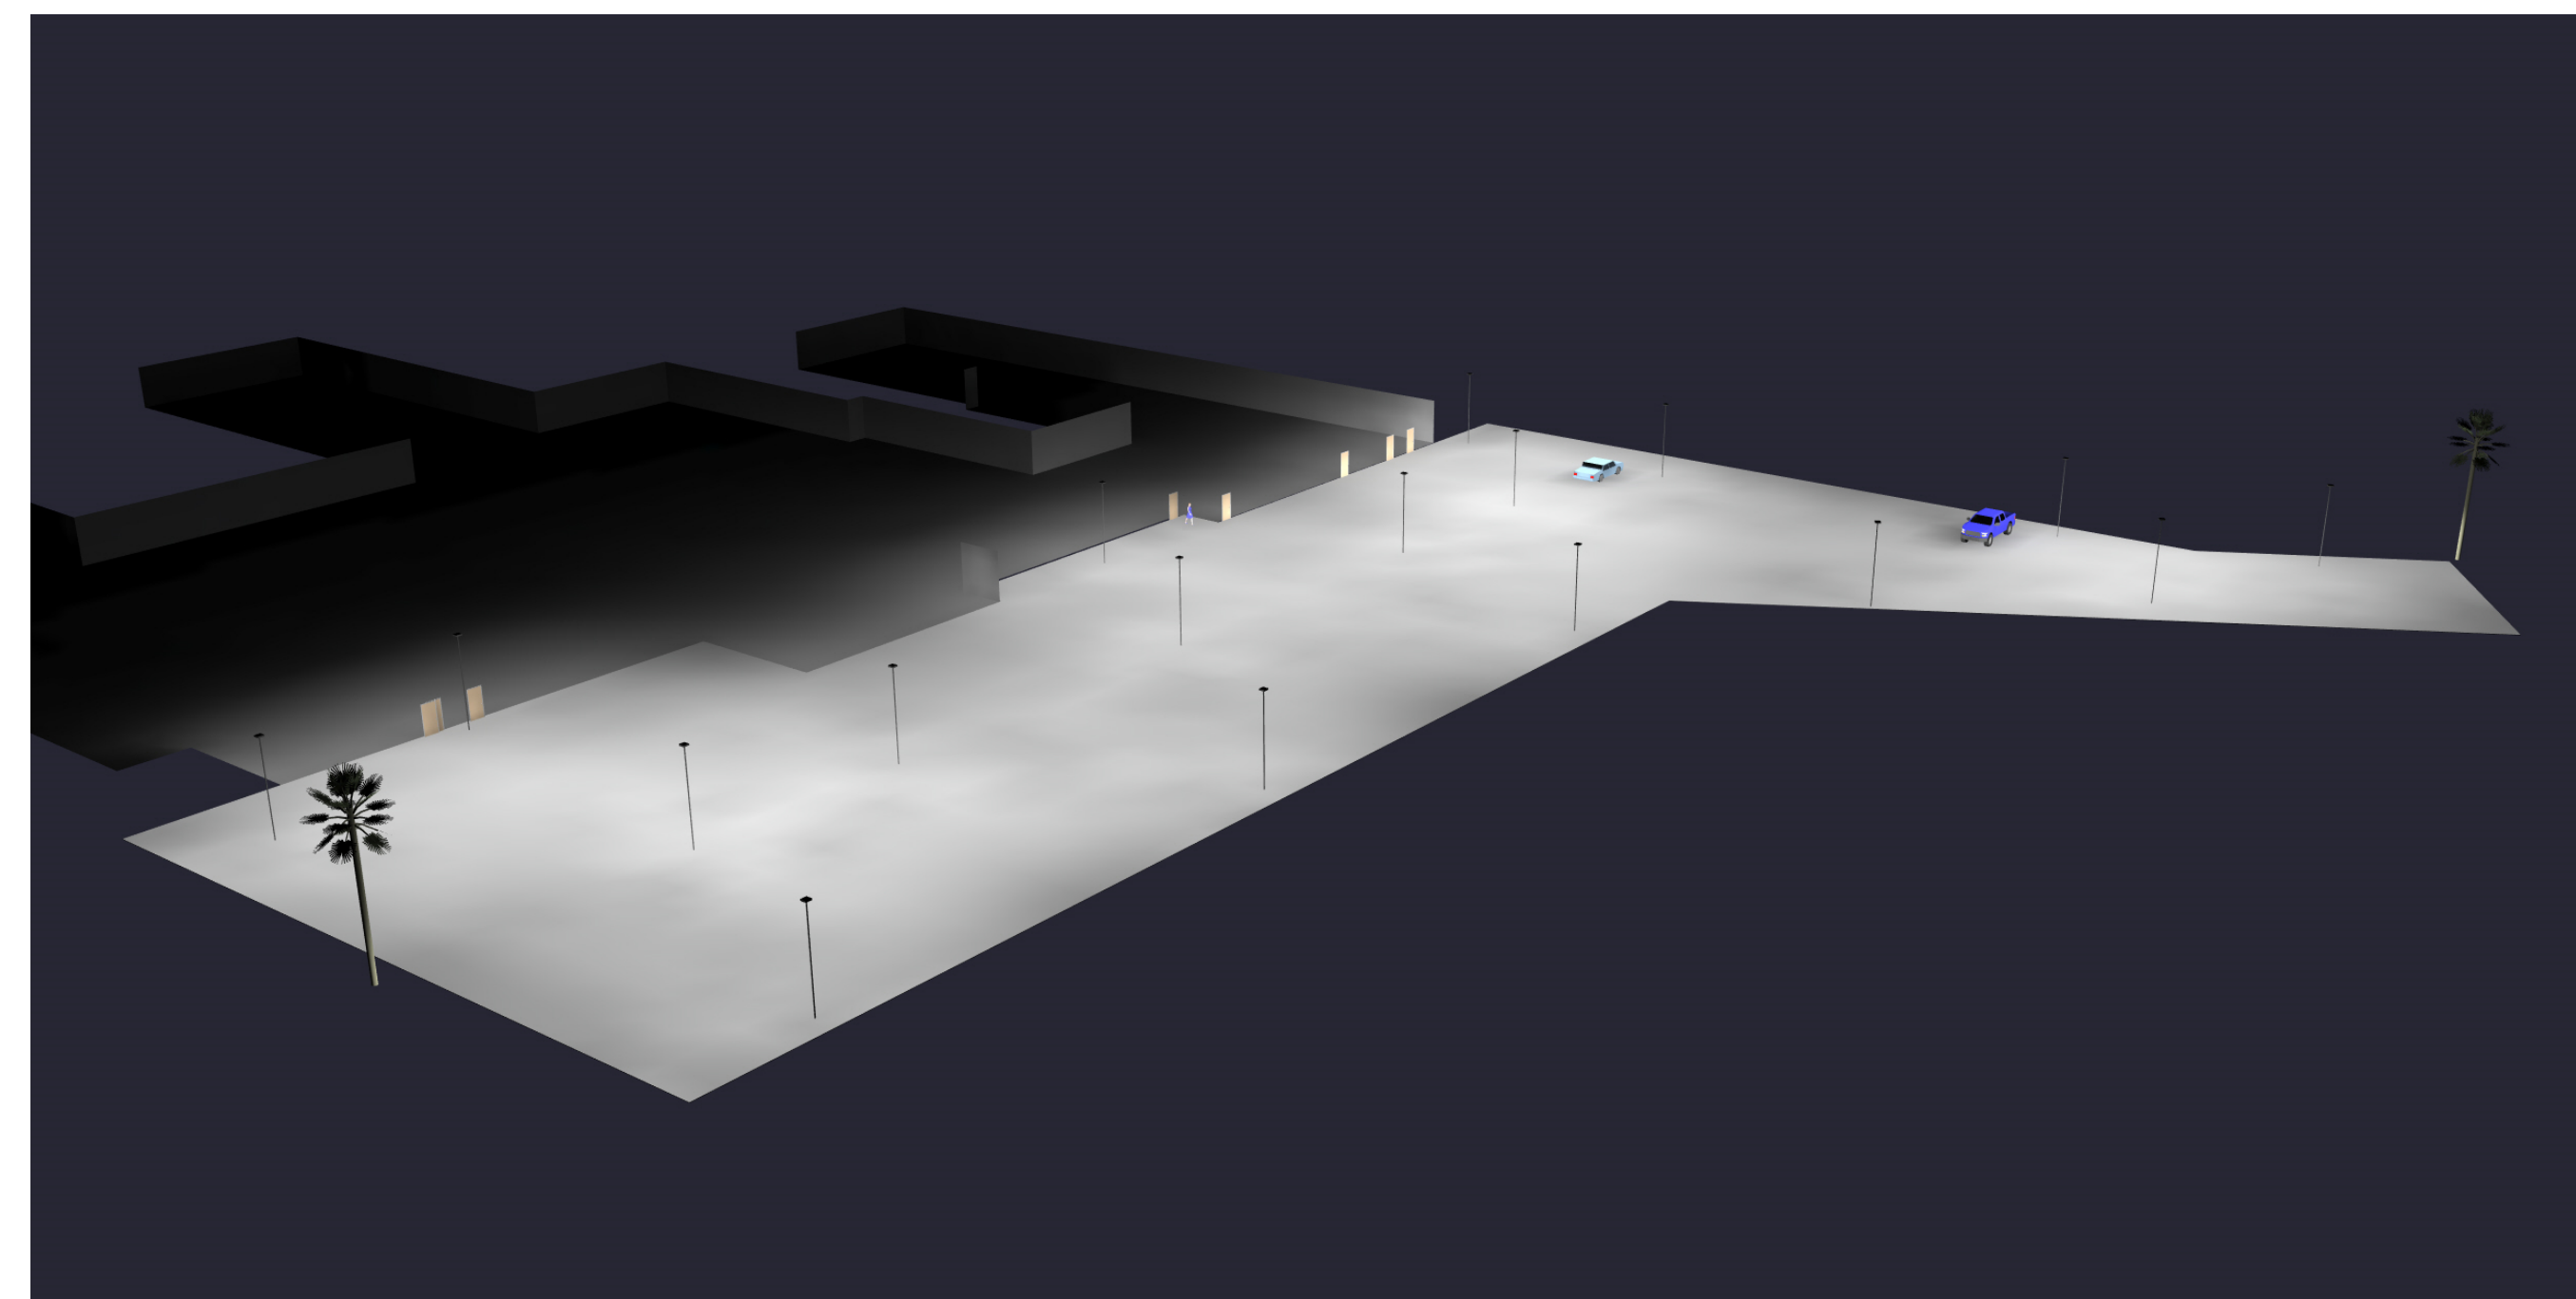

2 PARKING LOT RENDERING VIEW
A1.1 | A1.1 NOT TO SCALE



300 SPECTRUM CENTER DR, SUITE 730
IRVINE, CALIFORNIA 92618
949.727.9000

PROJECT 000000.00

PACIFIC GROVE ACUTE PSYCHIATRIC FACILITY

5900 Brockton Ave., Riverside, CA
92506

DEVELOPMENT APPLICATION / CUP

DATE
REVISIONS
DESCRIPTION DATE


SHEET TITLE

PHOTOMETRIC PLAN

SHEET NUMBER

E1.1

3/28/2025 2:05:11 PM
Autodesk Docs://246459.MXD Pacific Grove Acute Psych H25124-0555.MXD E2.01_CENTRAL.rvt
©BOULDER ASSOCIATES
DESIGNED & DRAWN BY: [NAME]
CHECKED BY: [NAME]
PRINTED BY: [NAME]

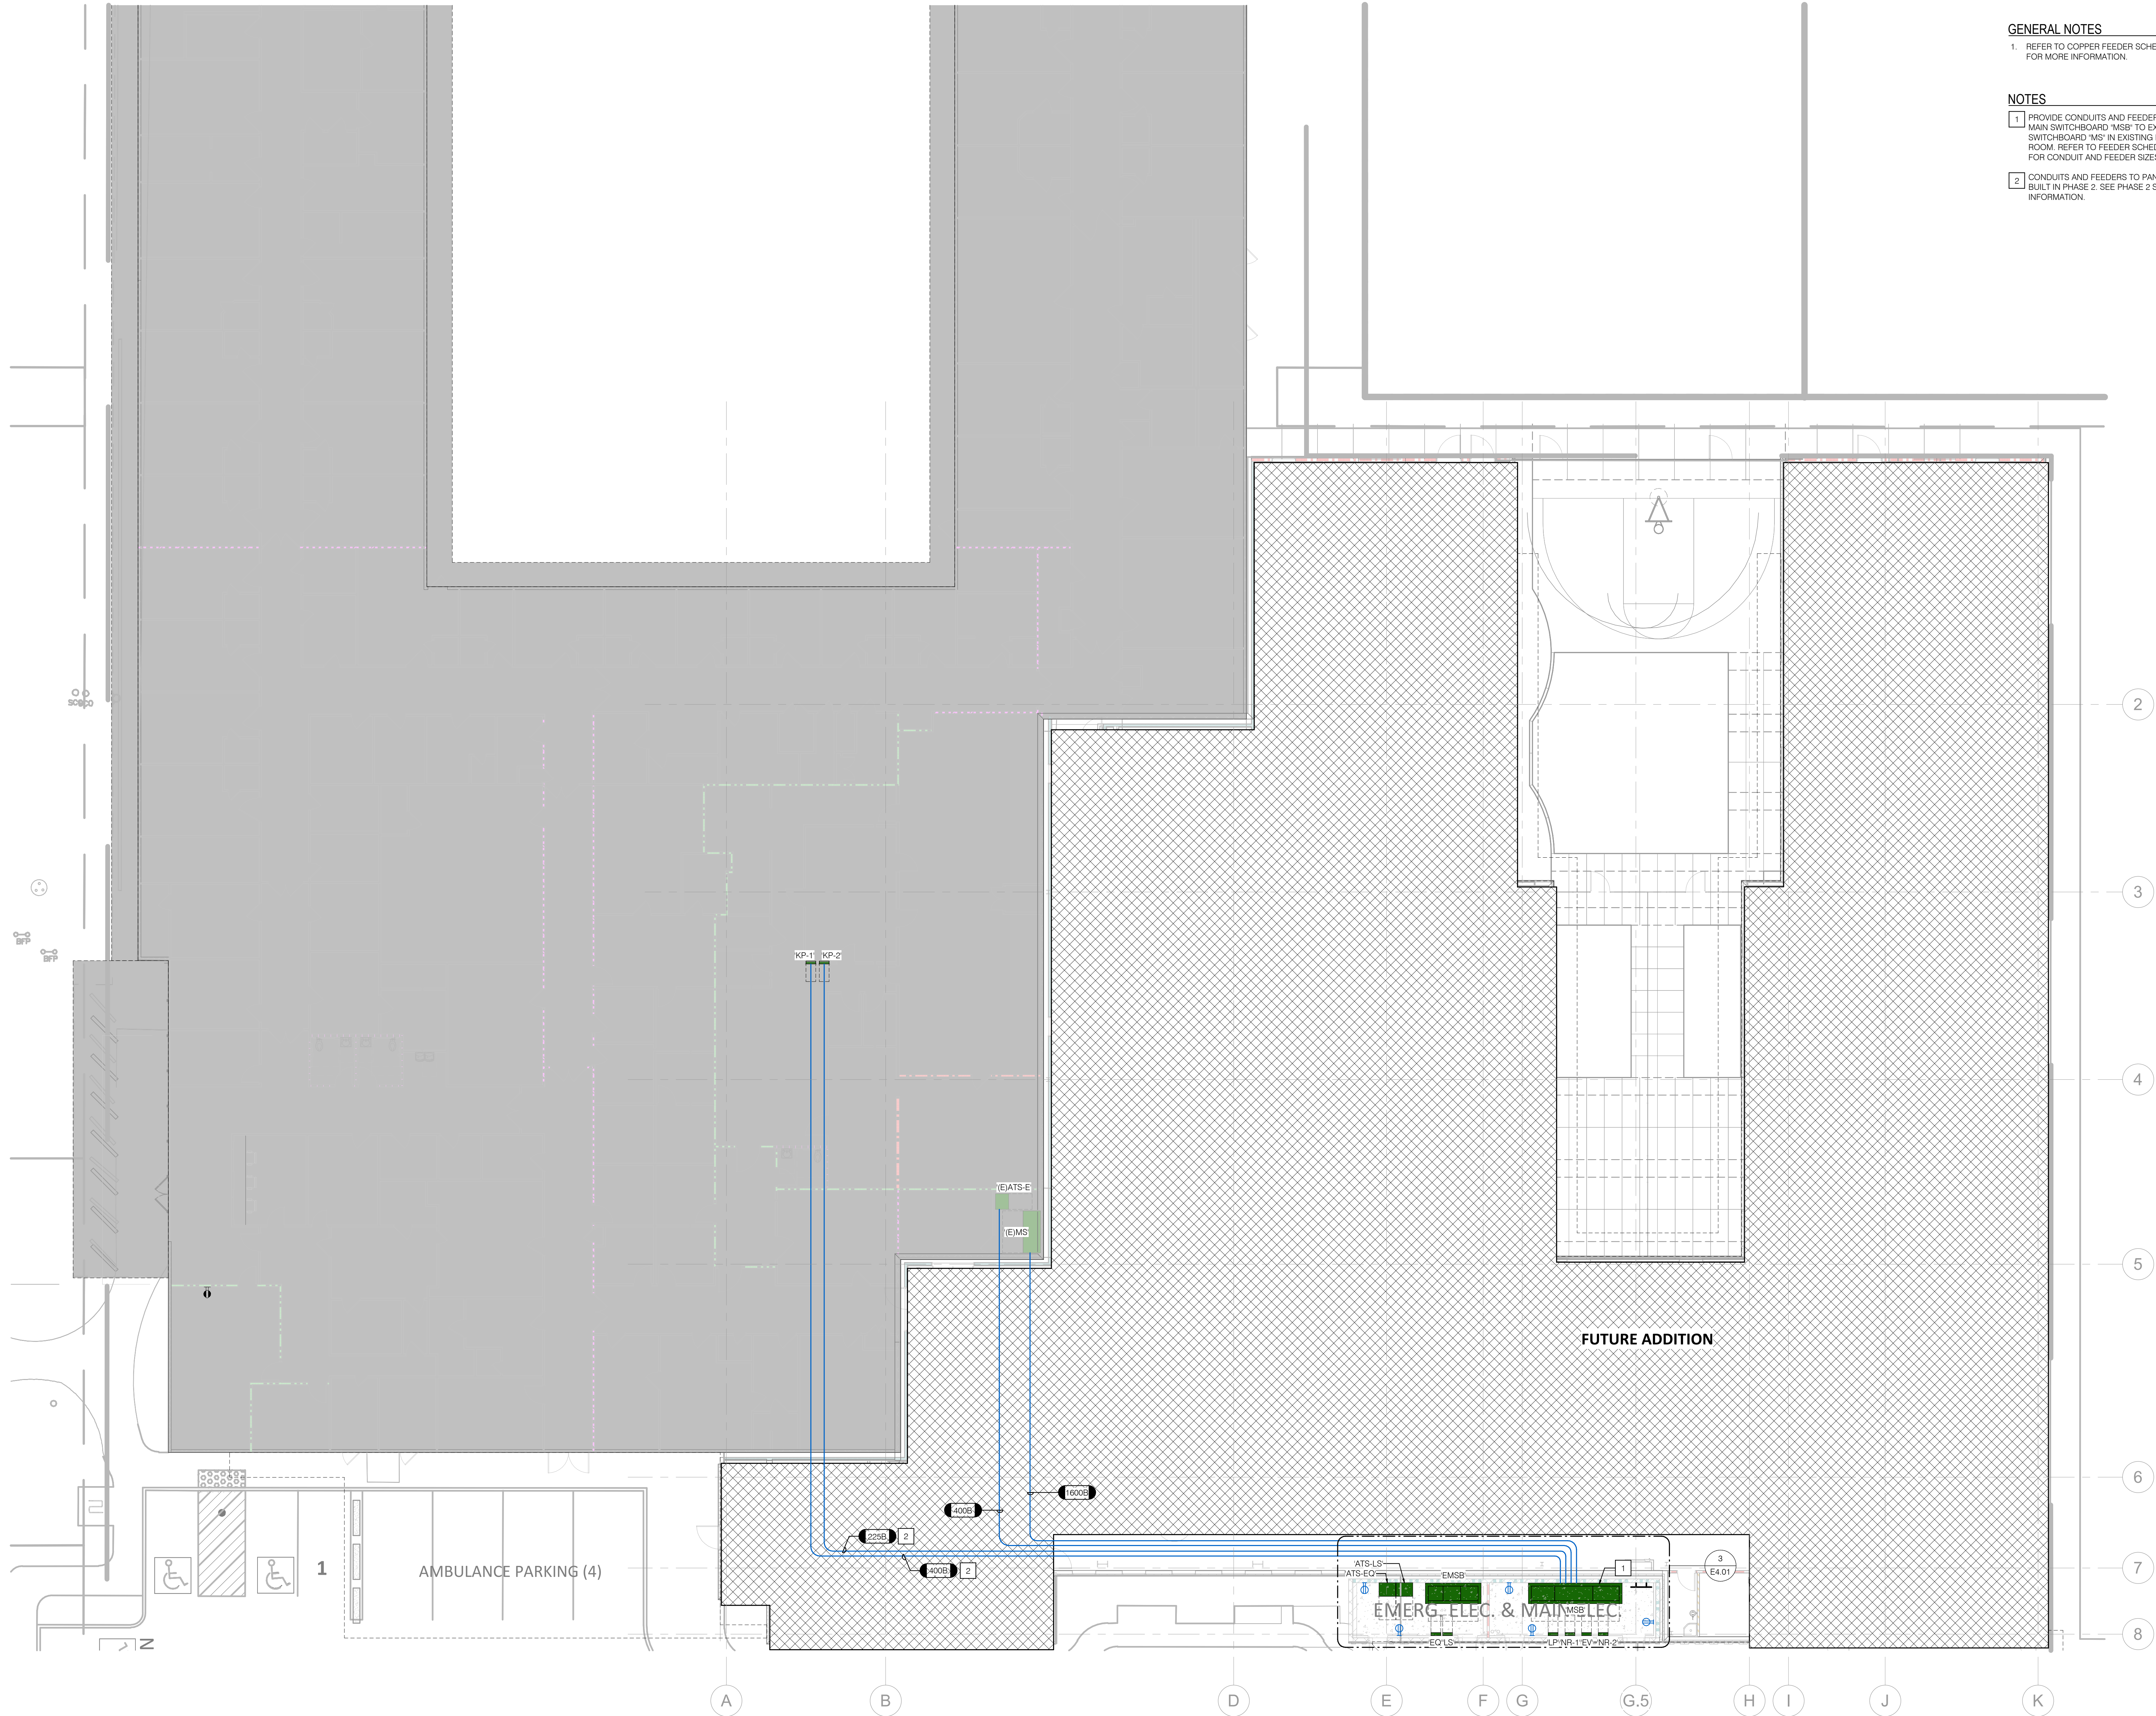

1 FIRST FLOOR PLAN
SCALE: 3/32" = 1'-0"

GENERAL NOTES

1. REFER TO COPPER FEEDER SCHEDULE ON SHEET E5.01 FOR MORE INFORMATION.

NOTES

1. PROVIDE CONDUITS AND FEEDERS TO CONNECT FROM MAIN SWITCHBOARD 'MSB' TO EXISTING 1600A SWITCHBOARD 'MS' IN EXISTING BUILDING'S ELECTRICAL ROOM. REFER TO FEEDER SCHEDULE ON SHEET E5.01 FOR CONDUIT AND FEEDER SIZES.
2. CONDUITS AND FEEDERS TO PANEL KP-1 AND KP-2 TO BE BUILT IN PHASE 2. SEE PHASE 2 SHEET E2.01 FOR MORE INFORMATION.

BA
BOULDER ASSOCIATES
300 SPECTRUM CENTER DR., SUITE 730
IRVINE, CALIFORNIA 92618
949.727.9000

PROJECT P246459.00

**PACIFIC GROVE
ACUTE
PSYCHIATRIC
FACILITY**

5900 BROCKTON AVE., RIVERSIDE,
CA 92506

**DEVELOPMENT
APPLICATION / CUP**

DATE 03/28/2025

REVISIONS	DESCRIPTION	DATE
1		


HCAI
H241744-33-00
APPROVAL STAMP

SHEET TITLE
**FIRST FLOOR POWER
PLAN**


SHEET NUMBER
E2.01

LIGHT FIXTURE SCHEDULE


IMAGE	TYPE	FIXTURE DESCRIPTION	MANUFACTURER & MODEL	TOTAL V-A	LAMP TYPE	LUMENS	COLOR TEMP	CRI	VOLTAGE	MTG	NOTES
	P1	4' LINEAR STRIP	FSC LIGHTING #L285-48-40W-35K-E5 (CUSTOM 90+ CRI)-10GL	40	LED	5200	3500K	90	120	PENDANT	
	W1	WALL MOUNTED LED	LITHONIA LIGHTING#ARC2LED-P4-30K-MVOLT-PE-EBWC-X	30	LED	3903	3000K	80	120	WALL	

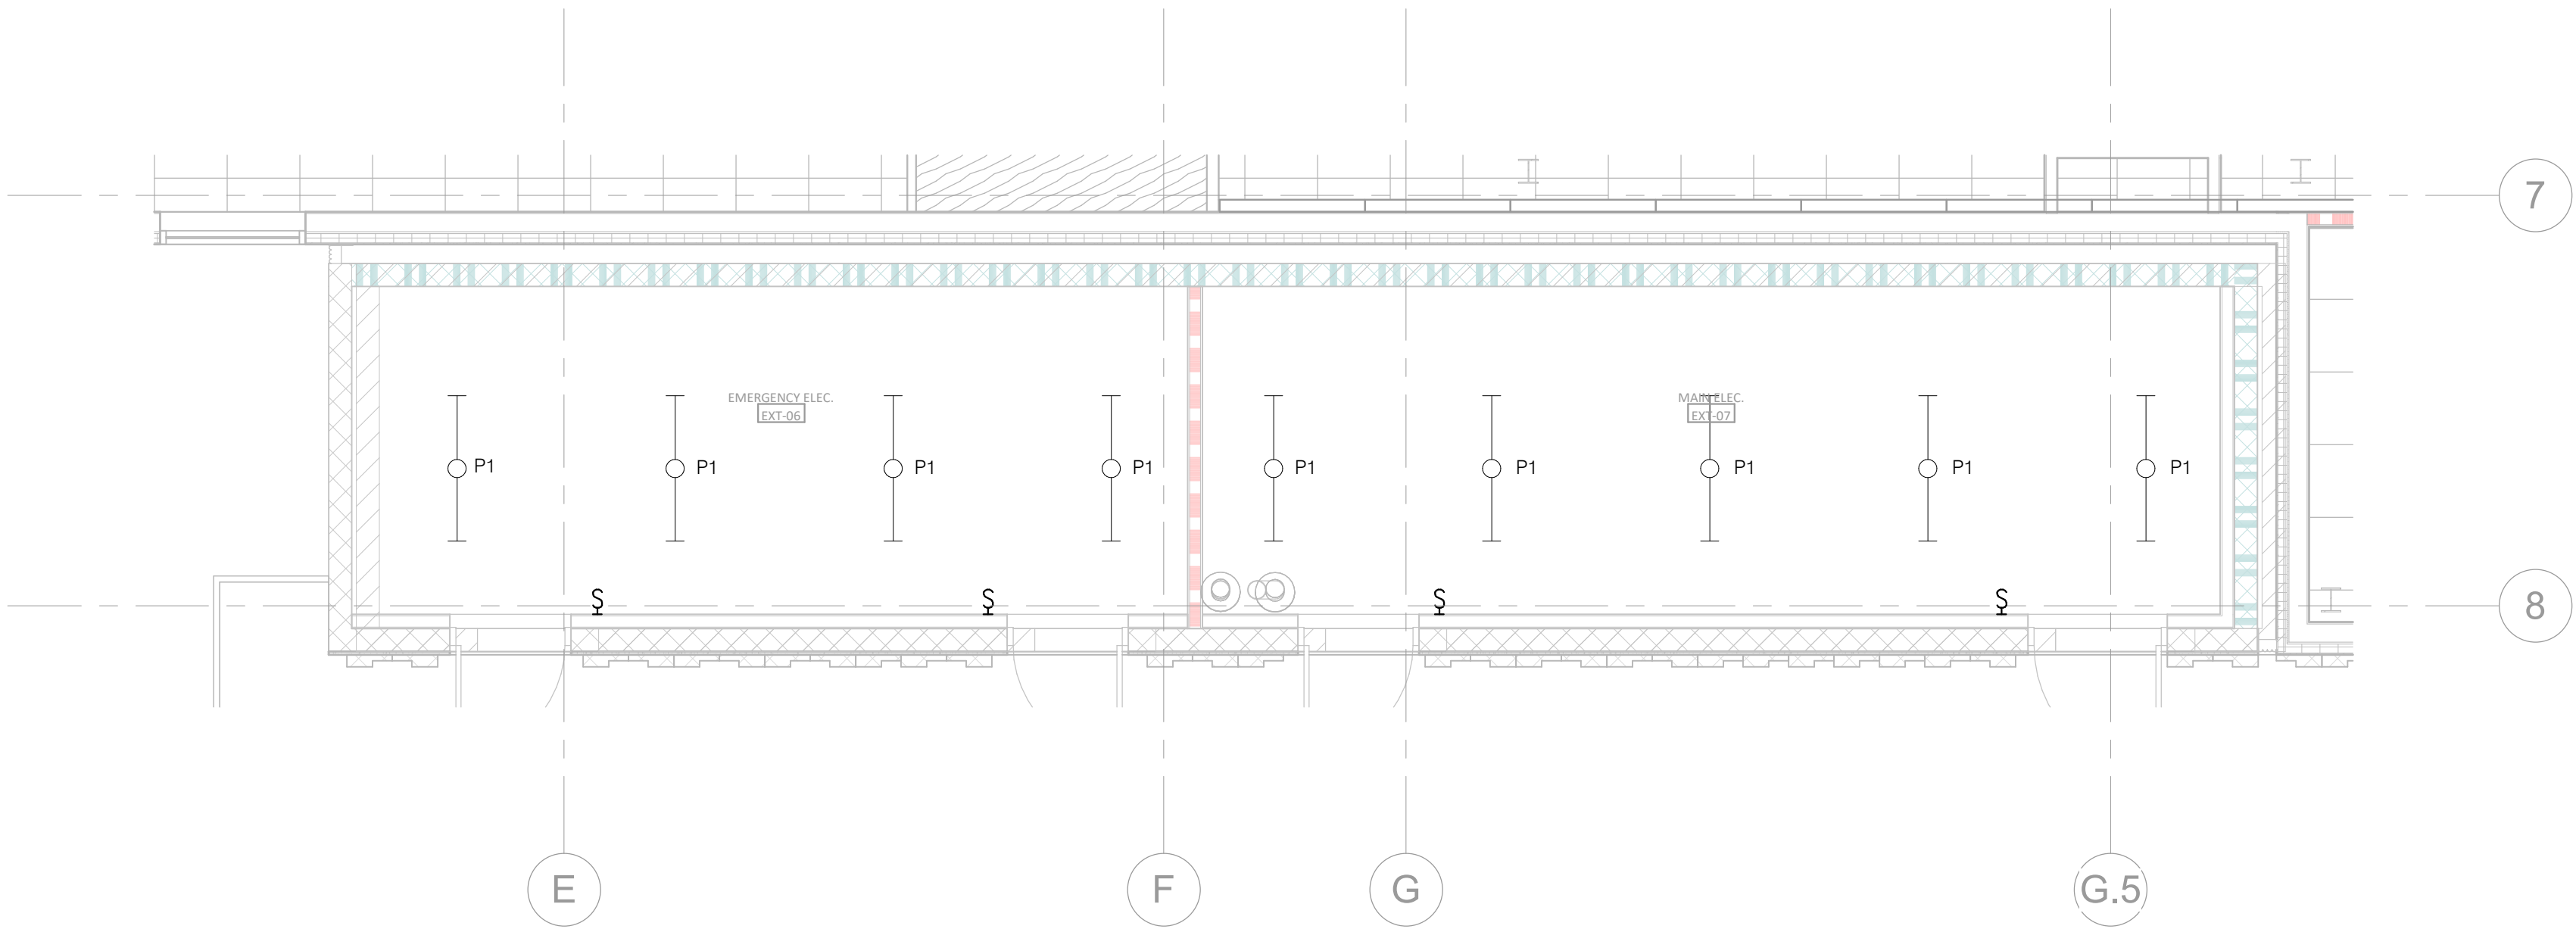


4 MAIN ELECTRICAL ROOM - LIGHTING PLAN
SCALE: 1/4" = 1'-0"

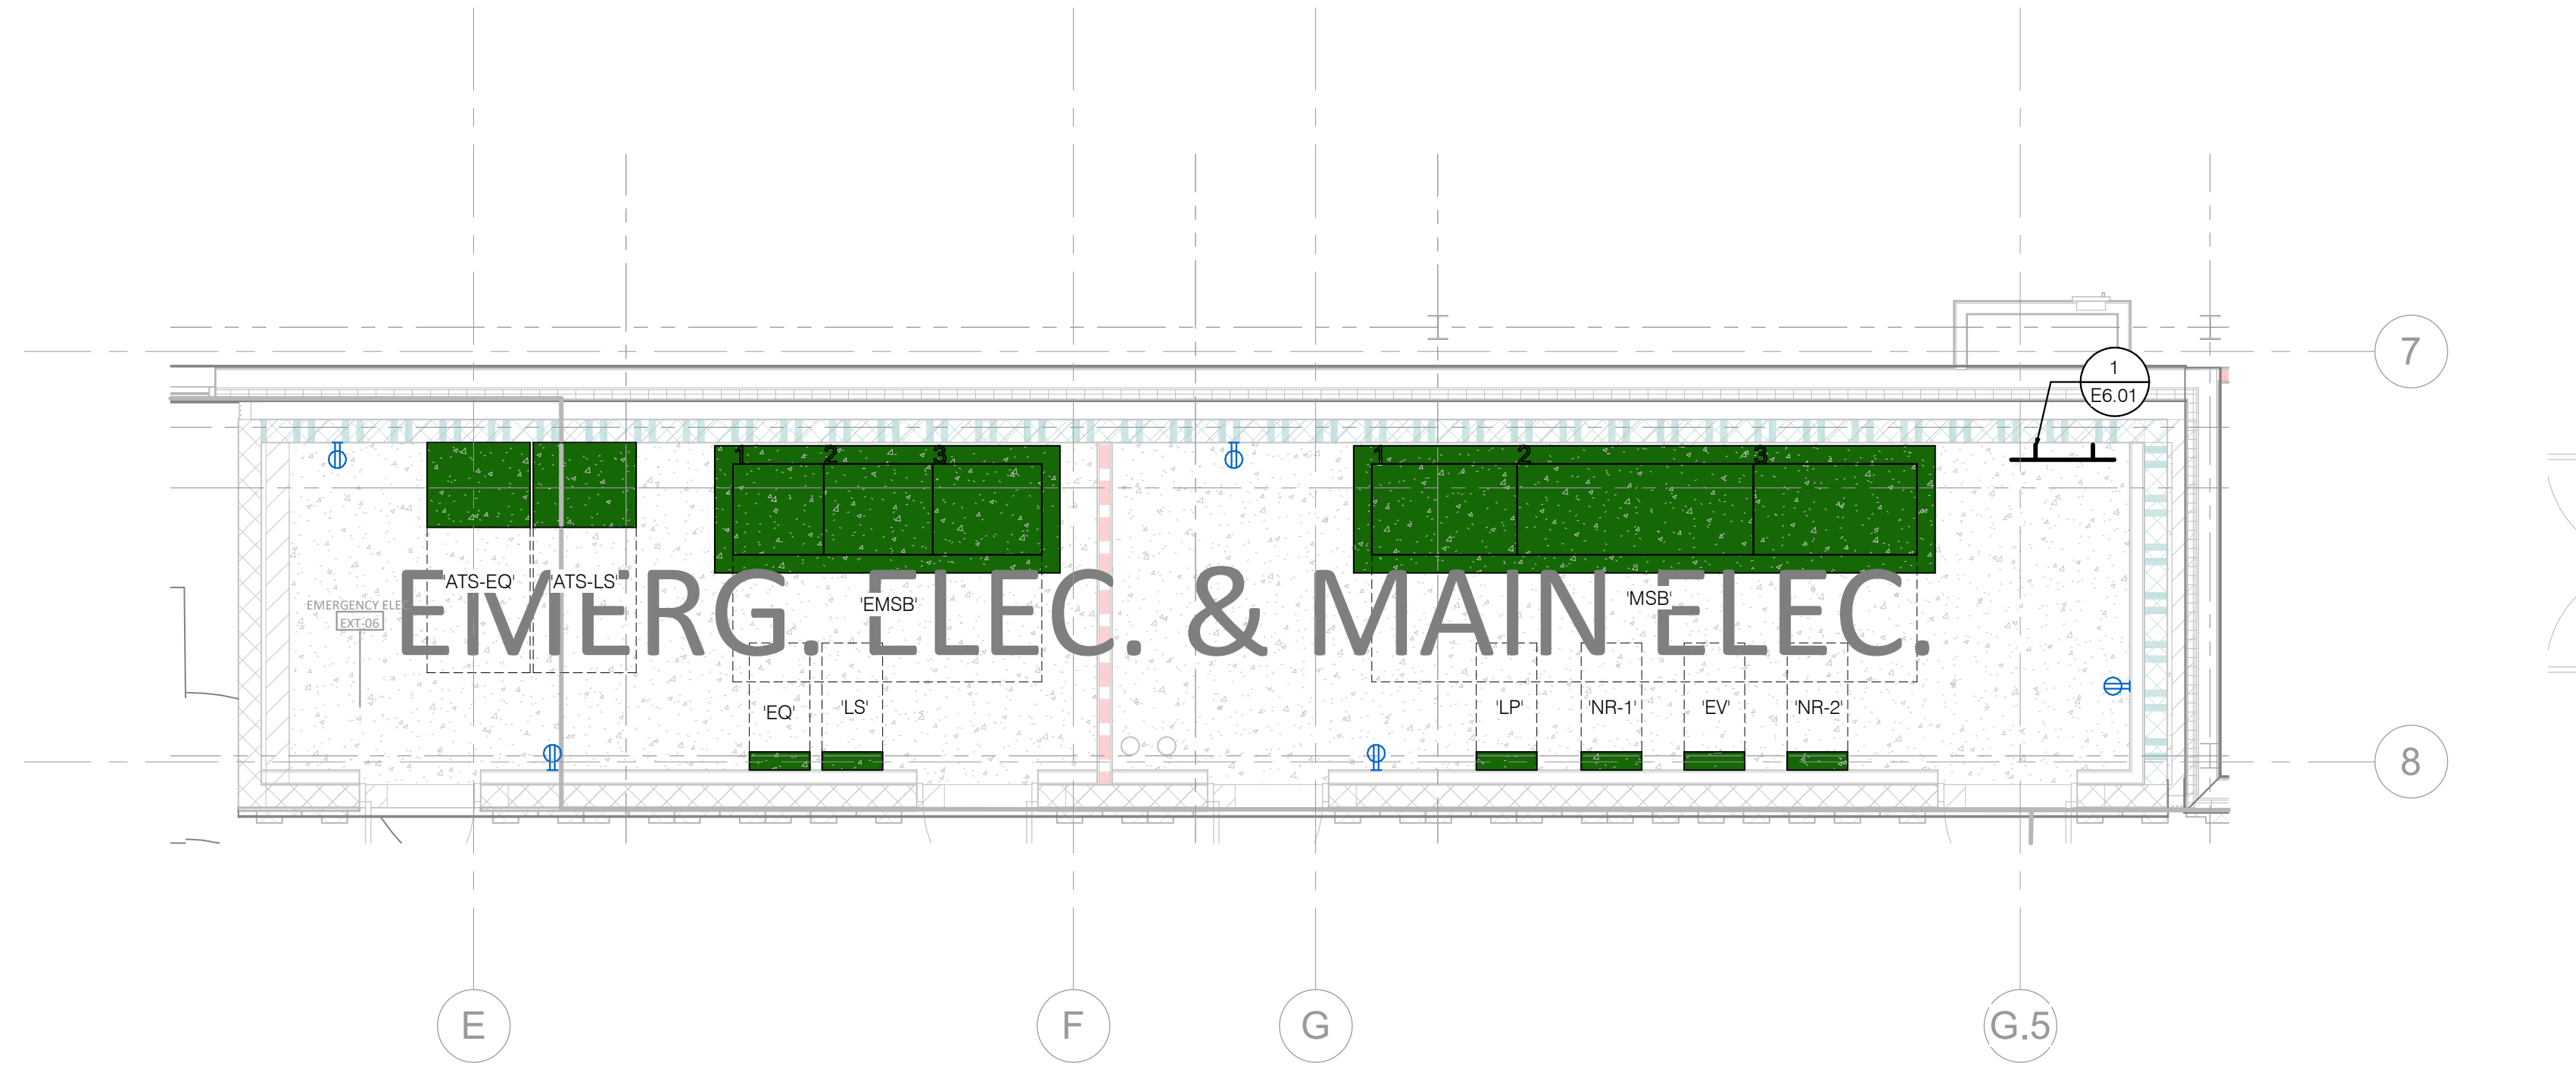

3 MAIN ELECTRICAL ROOM - POWER PLAN
SCALE: 1/4" = 1'-0"

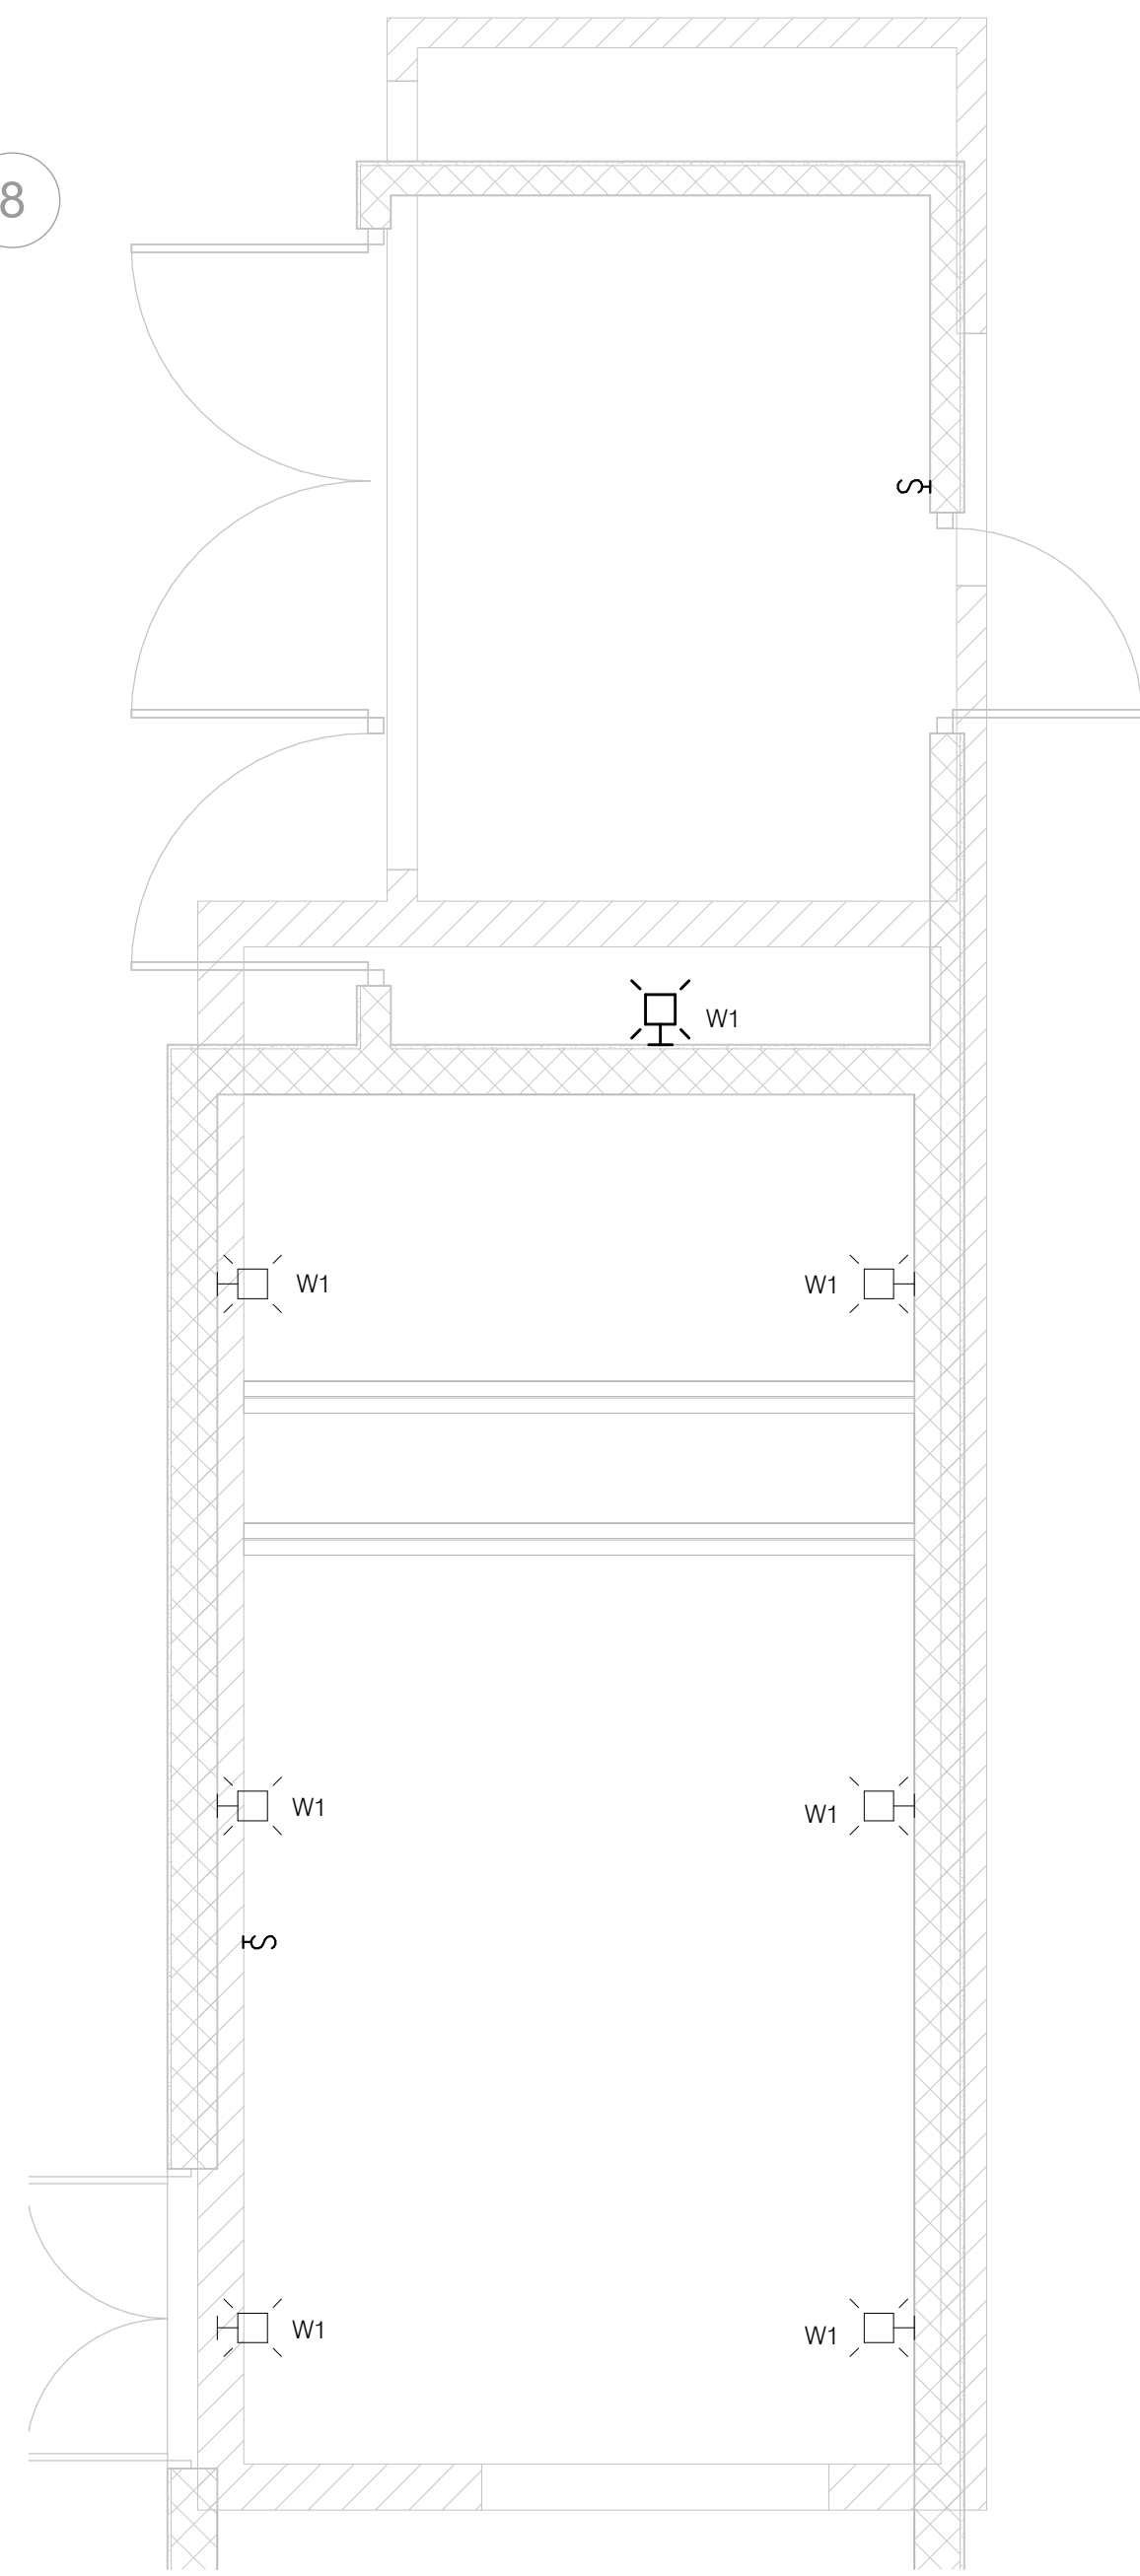

2 GENERATOR YARD - LIGHTING PLAN
SCALE: 1/4" = 1'-0"

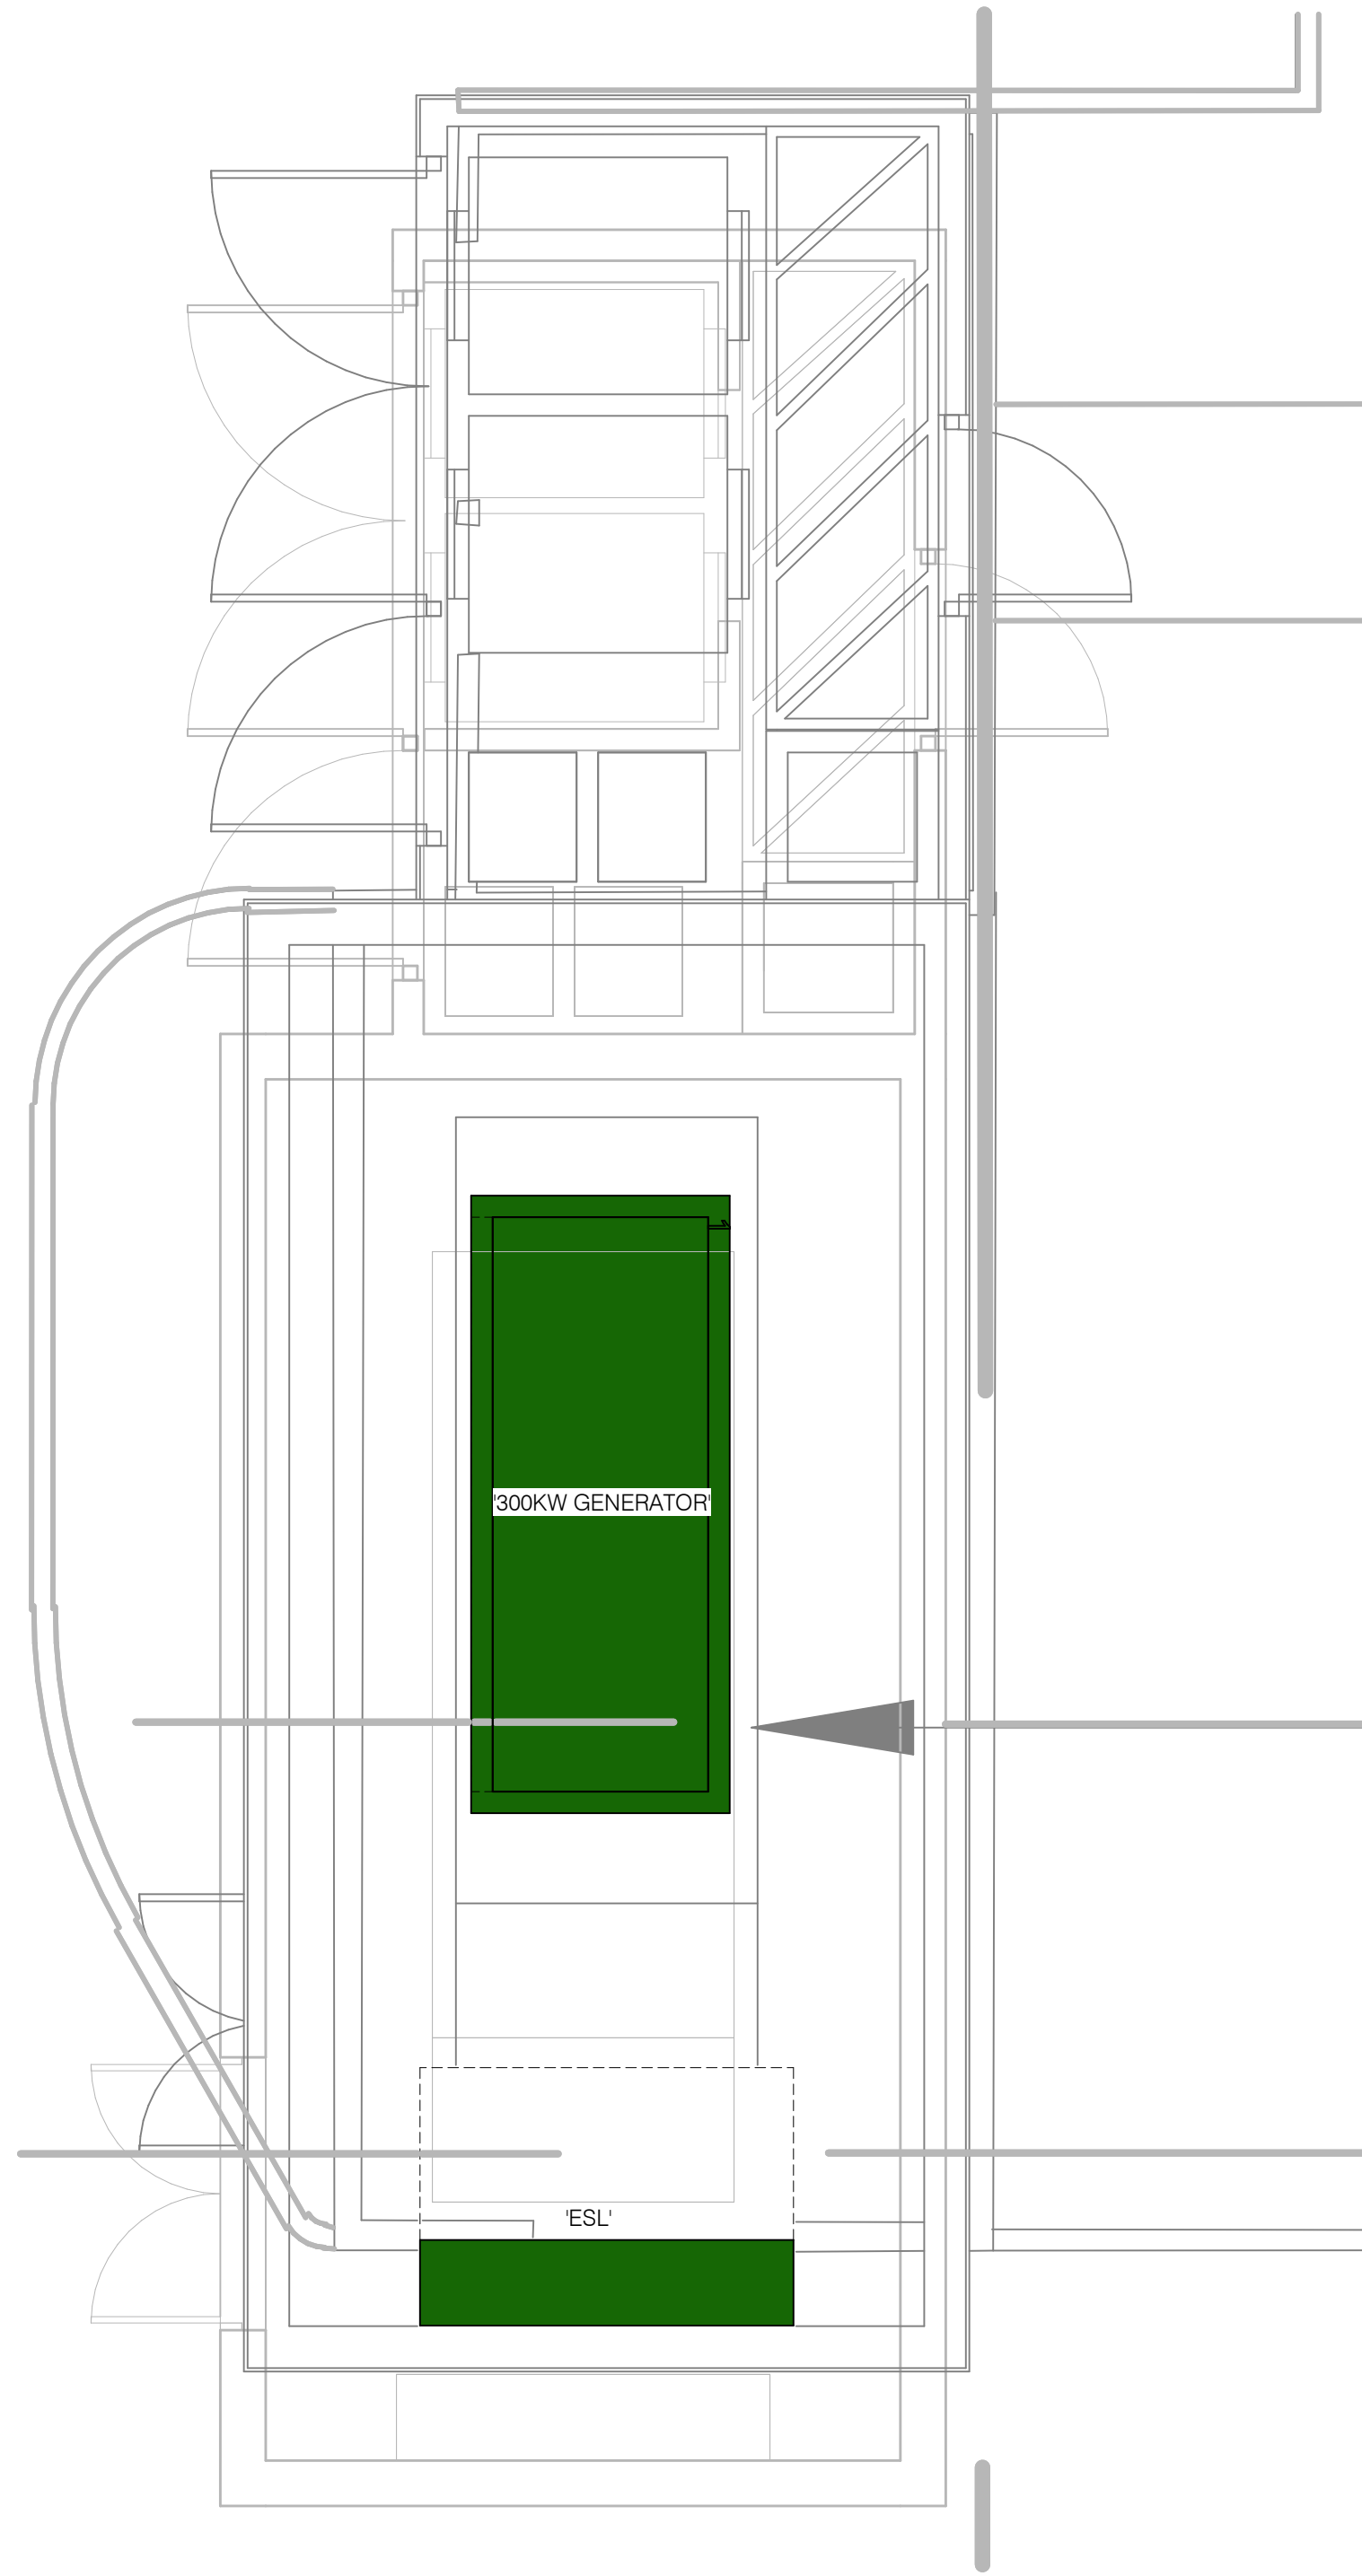

1 GENERATOR YARD - POWER PLAN
SCALE: 1/4" = 1'-0"



BOULDER ASSOCIATES

300 SPECTRUM CENTER DR, SUITE 730
IRVINE, CALIFORNIA 92618
949.727.9000

PROJECT P246459.00

PACIFIC GROVE
ACUTE
PSYCHIATRIC
FACILITY

5900 BROCKTON AVE., RIVERSIDE,
CA 92506

DEVELOPMENT
APPLICATION / CUP

DATE 03/28/2025

REVISIONS
DESCRIPTION DATE

HCAI
H241744-33-00

APPROVAL STAMP

SHEET TITLE

ENLARGED PLANS

SHEET NUMBER

E4.01

3/28/2025 2:05:13 PM
Autodesk Docs://246459.MW Pacific Grove Acute Psych K25/24-0556_MWPT_K25_GENERAL.rvt
H241744-33-00
3/28/2025 2:05:13 PM
Autodesk Docs://246459.MW Pacific Grove Acute Psych K25/24-0556_MWPT_K25_GENERAL.rvt
H241744-33-00
3/28/2025 2:05:13 PM
Autodesk Docs://246459.MW Pacific Grove Acute Psych K25/24-0556_MWPT_K25_GENERAL.rvt
H241744-33-00



BOULDER ASSOCIATES
300 SPECTRUM CENTER DR, SUITE 730
IRVINE, CALIFORNIA 92618
949.727.9000

PROJECT P246459.00

PACIFIC GROVE
ACUTE
PSYCHIATRIC
FACILITY

5900 BROCKTON AVE., RIVERSIDE,
CA 92506

DEVELOPMENT
APPLICATION / CUP

DATE 03/28/2025

REVISIONS	DESCRIPTION	DATE
1		


HCAI
H241744-33-00
APPROVAL STAMP

SHEET TITLE


DETAILS

SHEET NUMBER

E6.01

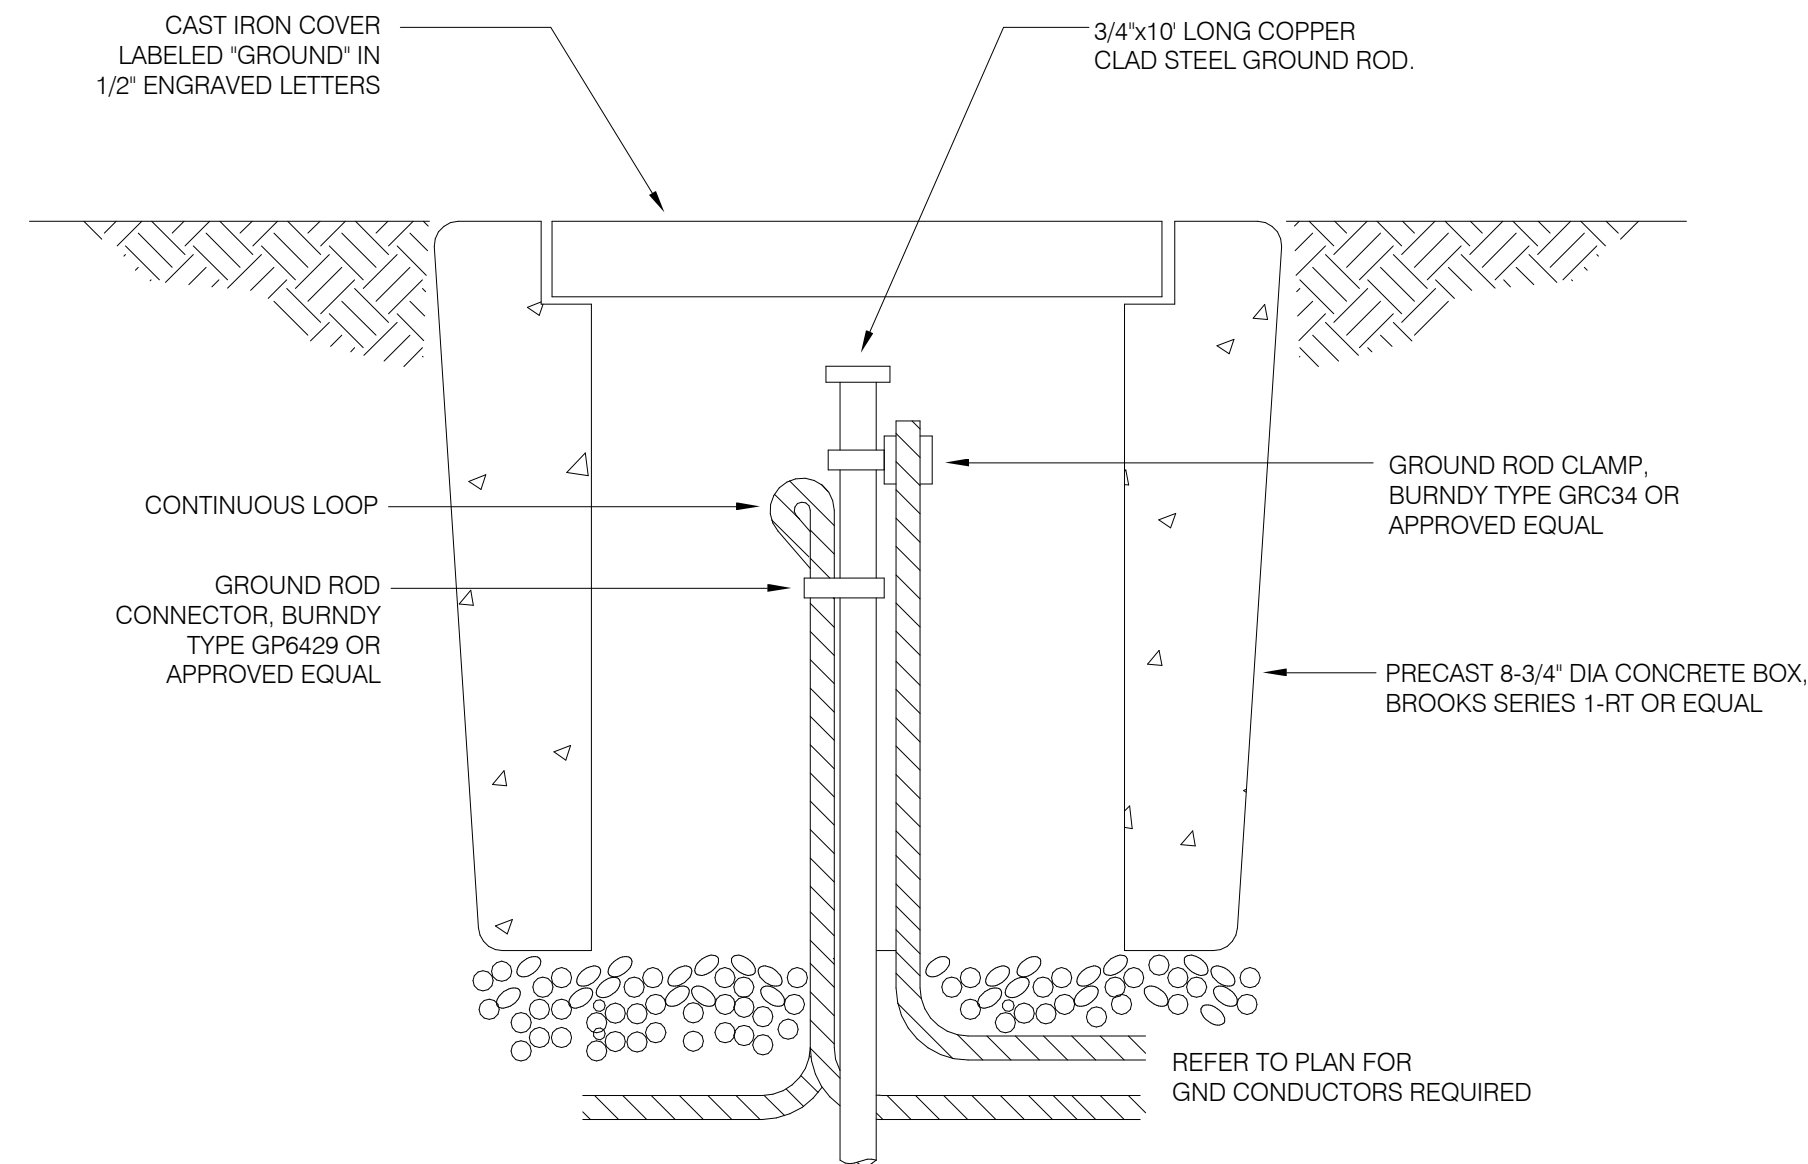

2 GROUND ROD AND WELL
NO SCALE

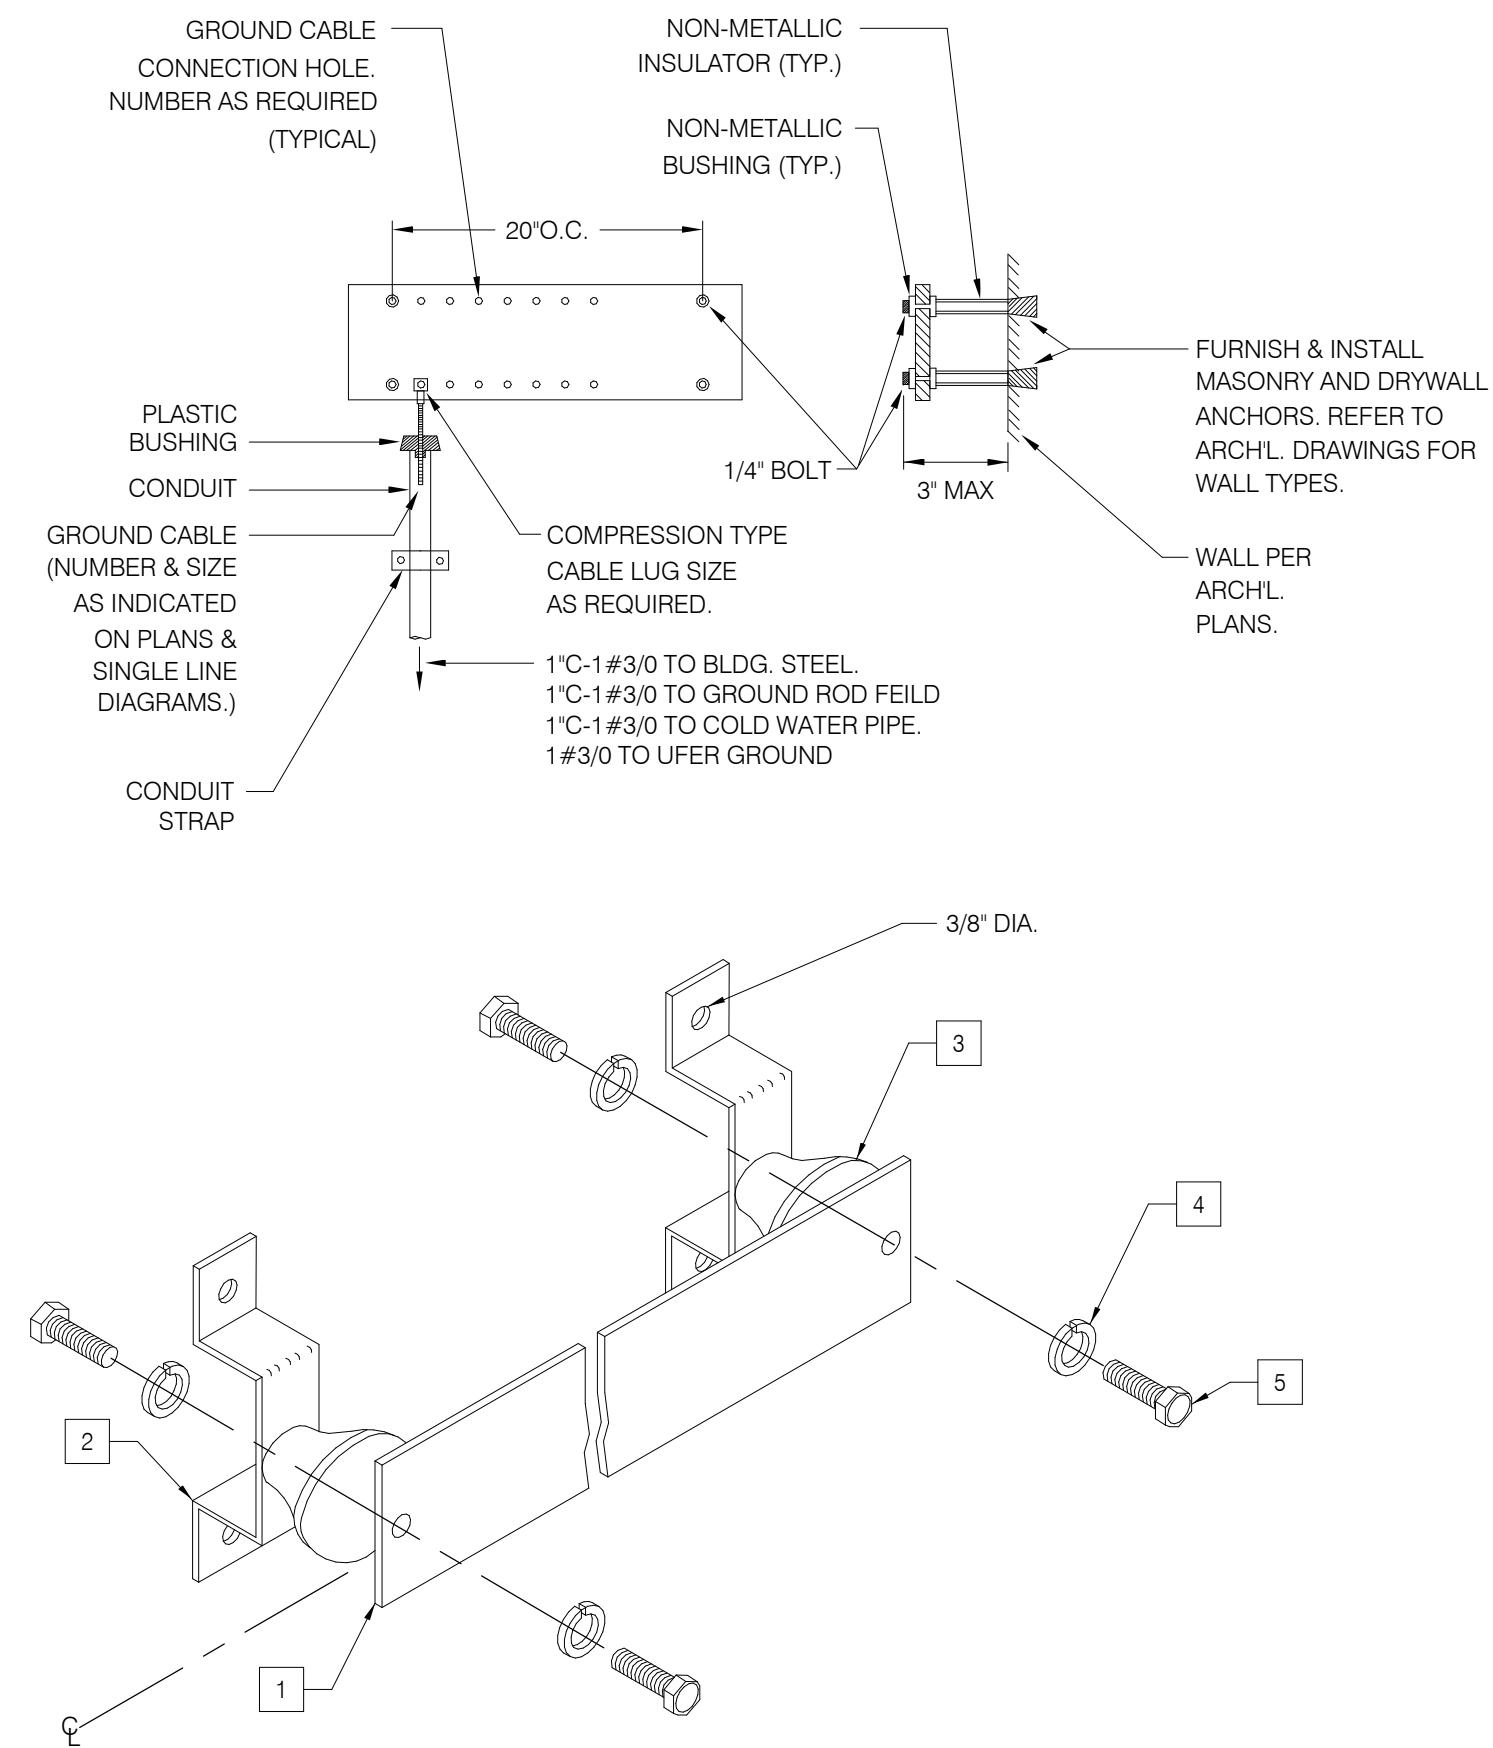


NOTES

- GROUNDING BAR CU 1/4" X 6" X LENGTH AS INDICATED ON DRAWINGS.
- WALL MOUNTING BRACKET - 2 REQUIRED.
- INSULATORS - 2 REQUIRED.
- 5/8"-11 X 1 H.H.C.S. - 4 REQUIRED.
- 5/8" LOCKWASHER - 4 REQUIRED.

1 GROUND BAR MOUNTING
NO SCALE

GENERAL NOTES

- ROUTE ALL GROUNDING CONDUCTORS INDEPENDENT OF CONDUITS.
- PROVIDE A CERTIFIED TEST OF GROUND RODS SHOWING THAT THE RESISTANCE TO GROUND IS 25 OHMS OR LESS.

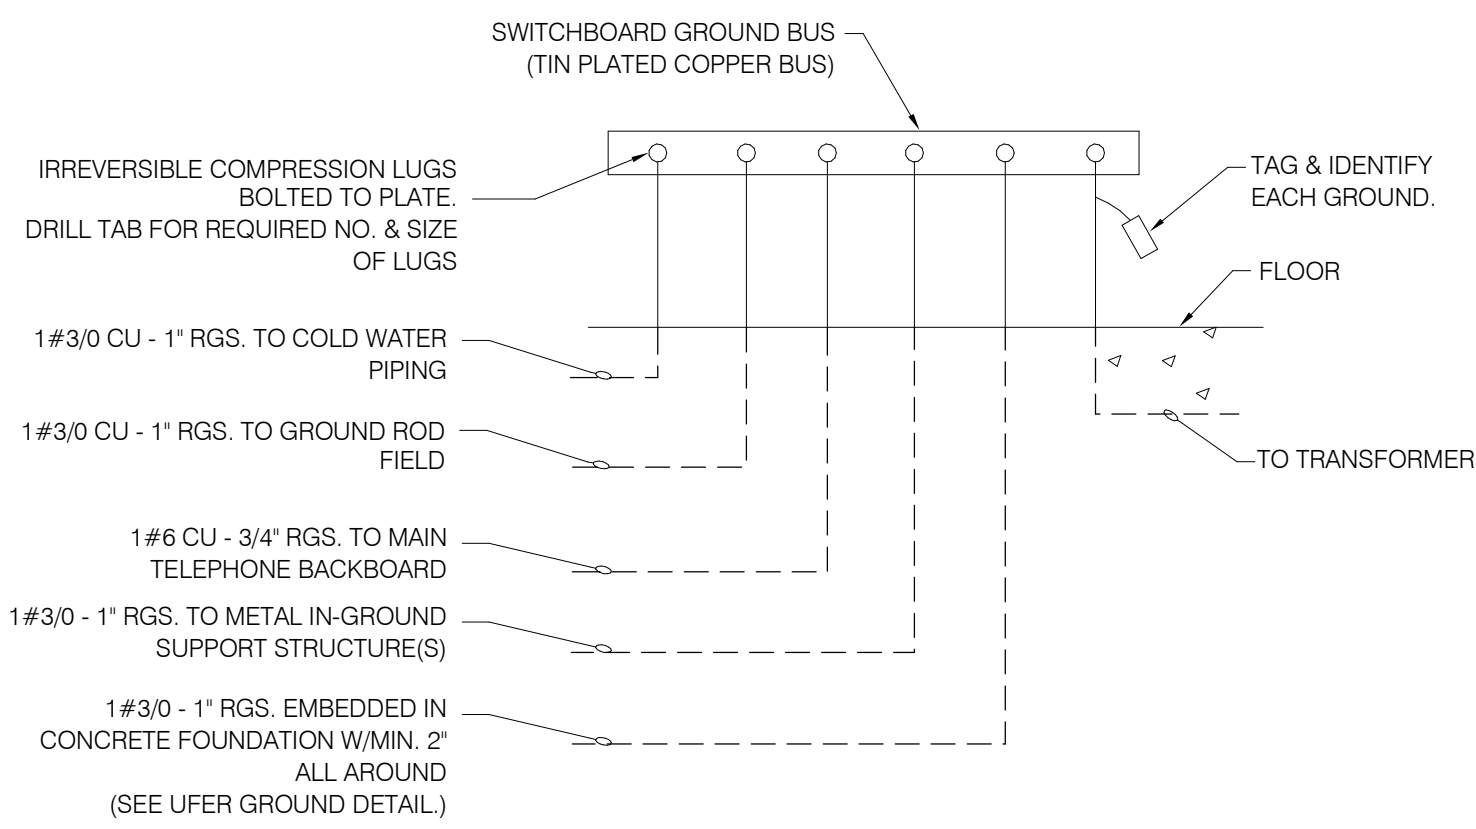

GENERAL NOTES

- THE TOTAL RESISTANCE MEASURED BETWEEN THE MAIN SERVICE GROUND BUS AND THE EARTH SHALL NOT EXCEED 25 OHMS UNDER DRY GROUND CONDITIONS.
- THE CONNECTION TO THE INTERIOR METAL WATER PIPING SHALL BE MADE WITHIN 5 FT. FROM THE POINT OF ENTRANCE TO THE BUILDING.

3 SWITCHBOARD GROUNDING
NO SCALE